 


¹ ALL REFERENCES ARE TO DIVISION B OF THE OBC, UNLESS PRECEDED BY [A] FOR DIVISION A AND [C] FOR DIVISION C

1. FIELD VERIFY ALL DIMENSIONS.
2. CONFORM TO THE REQUIREMENTS OF THE OBC (ONTARIO BUILDING CODE) INCLUDING ALL STANDARDS REFERENCING THEREIN, AND ANY APPLICABLE ACTS OF AUTHORITY HAVING JURISDICTION. (USE OF CODES AND STANDARDS SHALL APPLY.)
3. THIS SET OF DRAWINGS SUPERCEDES AND REPLACES ALL PREVIOUSLY RELEASED DRAWINGS.
4. DO NOT SCALE THE DRAWINGS.
5. THE CONTRACTOR SHALL BE RESPONSIBLE TO VERIFY ALL SITE CONDITIONS AND MEASUREMENTS. ANY DISCREPANCIES OR UNSATISFACTORY CONDITIONS IMMEDIATELY TO THE CONSULTANT, WHICH MAY ADVERSELY AFFECT THE PROPER COMPLETION OF THE JOB BEFORE PROCEEDING WITH THE WORK.
6. ALL WORK IS TO BE PERFORMED IN ACCORDANCE WITH THE OCCUPATIONAL HEALTH AND SAFETY ACT AND REGULATIONS FOR CONSTRUCTION PROJECTS.
7. FIELD VERIFY ALL DIMENSIONS IN CONJUNCTION WITH ALL OTHER CONTRACT DOCUMENTS.
8. WHERE DISCREPANCIES EXIST BETWEEN CONTRACT DOCUMENTS INCLUDING DRAWINGS AND APPLICABLE CODES AND ACTS, THE MOST STRINGENT SHALL GOVERN.
9. THE CONTRACTOR SHALL VISIT THE SITE AND FAMILIARIZE THEMSELVES WITH ALL MATERIALS, METHODS, AND DESIGN DETAILS PRIOR TO CONSTRUCTION.
10. THE CONTRACTOR SHALL CHECK ALL DIMENSIONS ON WORKING DRAWINGS AND REPORT ANY DISCREPANCIES TO THE CONSULTANT BEFORE PROCEEDING WITH THE WORK. ANY CHANGES, ALTERATIONS OR REVISIONS MUST BE REPORTED TO THE CONSULTANT BEFORE PROCEEDING WITH THE WORK.
11. THESE DESIGN DETAILS ARE THE PROPERTY OF THE DESIGN PROFESSIONAL WITH WHOM THE DESIGN PROFESSIONAL HAS ENTERED INTO A CONTRACT AND THERE ARE NO REPRESENTATIONS OF ANY KIND MADE BY THE DESIGN PROFESSIONAL TO ANY PARTY WITH WHOM THE DESIGN PROFESSIONAL HAS NOT ENTERED INTO A CONTRACT.
12. SUBSTITUTIONS FROM SPECIFIED PRODUCTS AND MATERIALS MUST BE APPROVED BY THE CONSULTANT PRIOR TO ORDERING OF MATERIALS. THE CONTRACTOR SHALL REIMBURSE ALL CONSULTANTS FOR ADDITIONAL COSTS INCURRED AS A RESULT OF REVIEWING ANY CHANGES MADE TO THE CONTRACT DOCUMENTS.
13. MECHANICAL AND ELECTRICAL ITEMS SHOWN ARE FOR REFERENCE ONLY. REFER TO MECHANICAL AND ELECTRICAL DRAWINGS FOR ALL RELATED DEMOLITION/CONSTRUCTION WORK.



A1.0	SITE PLAN, LEGENDS AND CODE MATRIX
A1.1	PARTIAL PLANS
A1.2	ROOF PLAN, SECTION AND DETAILS
M1.1	Mechanical Legend, Drawing List, Schedules
M1.2	Overall Floor Plan Mechanical
M1.3	Part Floor Plans Mechanical Demolition
M2.1	Part Floor Plan Mechanical
M2.2	Part Roof Plan and Details Mechanical
M2.3	Mechanical Details
E1.1	Electrical Legend, Drawing List, Abbreviations, Etc.
E1.2	Overall Floor Plan Electrical
E2.1	Part Floor Plans Electrical
E3.1	Electrical Details

 



All measurements must be checked on the work by the Contractor.
Do not scale the drawing.
Do not use this drawing for construction until sealed and signed by the Architect.
Signing Architect has exercised responsible control with respect to design activities.



376 Cambridge Street,
Goderich, ON

BID and PERMIT

scale : As indicated	
	
detail : a - Detail number b - Location drawing	
	
drawn : BHY	check : JM
date : 04 AUG 2026	sheet : A1.0
job : 2316.00	

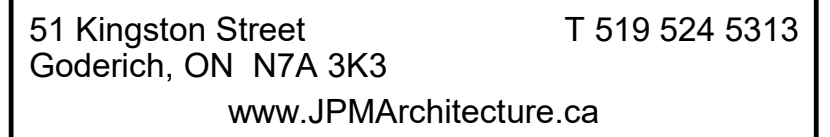

All measurements must be checked on the work by the Contractor.
Do not scale the drawing.
Do not use this drawing for construction until sealed and signed by the Architect.
Signing Architect has exercised responsible control with respect to design activities.



376 Cambridge Street,
Goderich, ON




PARTIAL PLANS

BID and PERMIT


detail : a - Detail number b - Location drawing	
--	---

date : 04 AUG 2026 sheet :


job :	2316.00	A.I.I	
-------	---------	-------	--

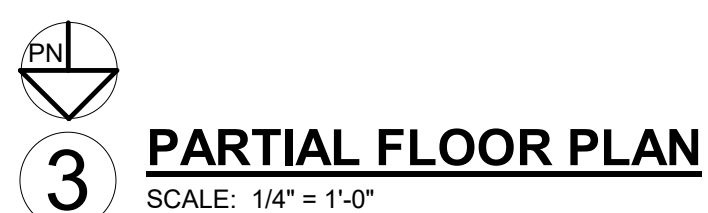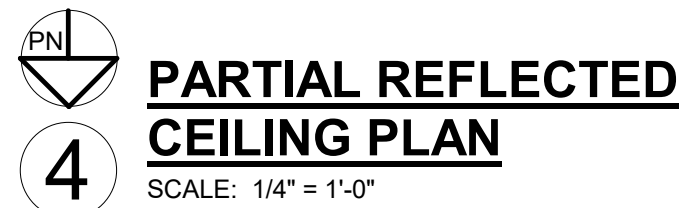 


- NOTE:**
1. ALL COUNTERS, CABINETS AND WORK TABLES ARE SUPPLIED AND PLACED BY KITCHEN EQUIPMENT SUPPLIED UNDER CASH ALLOWANCE.
 2. ALL KITCHEN EQUIPMENT SHOWN IS SUPPLIED AND PLACED BY KITCHEN EQUIPMENT SUPPLIED WITH FINAL CONNECTIONS BY CONTRACTOR

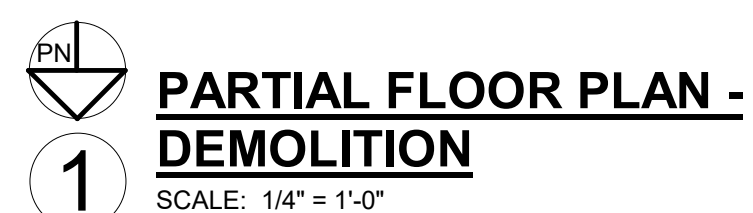


- ## DEMOLITION NOTES
1. DO NOT DAMAGE EXISTING BUILDING OR PORTIONS OF EXISTING BUILDING TO REMAIN. TAKE CARE NOT TO ENCRANCH ON ADJACENT OCCUPIED AREAS OR AREAS NOT WITHIN THE SCOPE OF WORK. PROTECT ALL EXISTING FINISHES THAT ARE TO REMAIN. PATCH AND MAKE GOOD ALL EXISTING ADJACENT SURFACES FINISHES AND MATERIALS WHERE DISTURBED OR DAMAGED BY NEW CONSTRUCTION.
 2. UNLESS NOTED OTHERWISE (UNO) REMOVE AND DISPOSE OF ALL EXISTING WALL MOUNTED ITEMS (E.G. MIRRORS, SOAP DISPENSERS, PAPER TOWEL DISPENSERS, ETC.) WITHIN THE AREA OF WORK AND TURN OVER TO OWNER.
 3. WHERE A WALL MOUNTED ITEM IS REMOVED PATCH AND REPAIR VOIDS AND MAKE WALL SURFACE READY TO RECEIVE FINISH INDICATED.

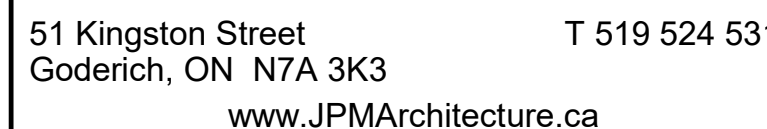


SCALE: 1/4" = 1'-0"

 


SCALE: 1/4" = 1'-0"

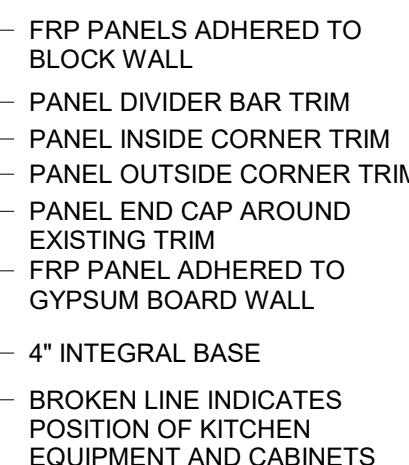

SCALE: 1/4" = 1'-0"

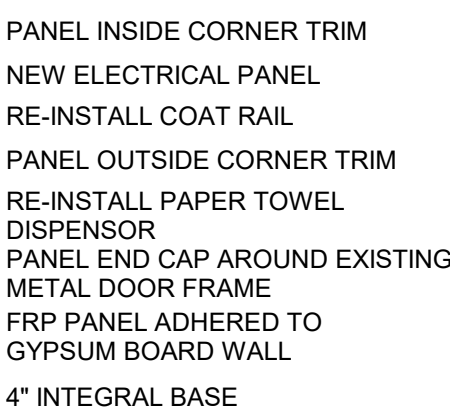


SCALE: 1/2" = 1'-0"

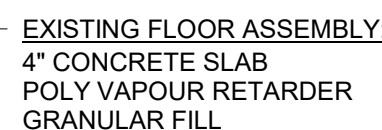


6 **SECTION 1**
SCALE: 1 1/2" = 1'-0"




SCALE: 3/4" = 1'-0"

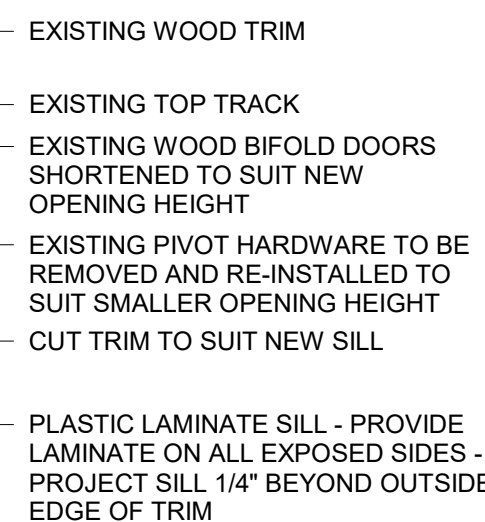


5 SCALE: 1 1/2" = 1'-0"

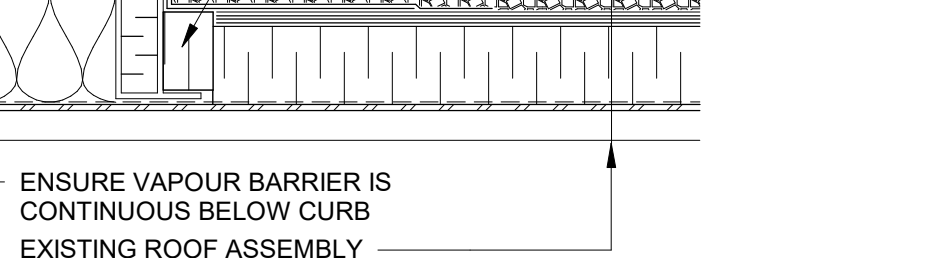


SCALE: 1" = 1'-0"

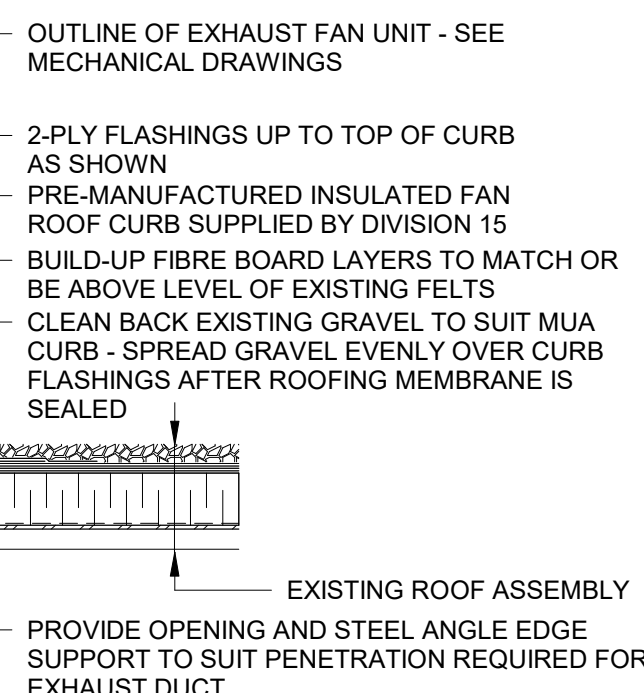

SCALE: 1 1/2" = 1'-0"

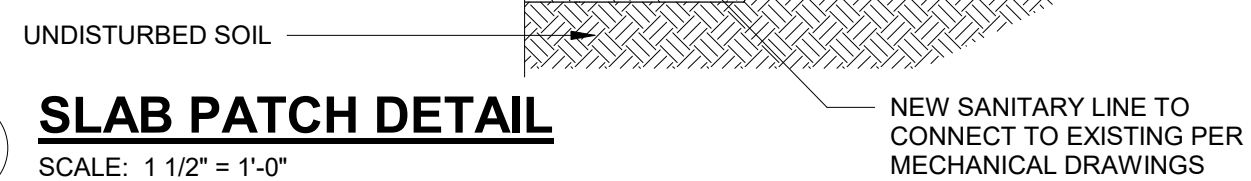

SCALE: 1/8" = 1'-0"

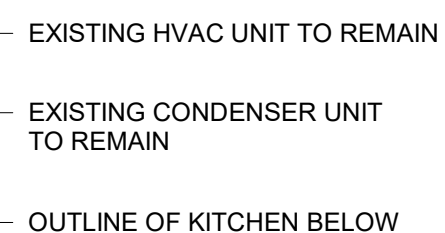

job : 2316.00



All measurements must be checked on the work by the Contractor.
Do not scale the drawing.
Do not use this drawing for construction until sealed and signed by the Architect.
Signing Architect has exercised responsible control with respect to design activities.

2026-07-31 2:31:35 PM

PROFESSIONAL ENGINEER

S.S. Sinclair

S.S. SINCLAIR
100214551

August 4 2017

100214551

PROVINCE OF ONTARIO

MECHANICAL DRAWING LIST	
M1.1	MECHANICAL LEGEND, DRAWING LIST SCHEDULES AND ABBREVIATIONS
M1.2	OVERALL FLOOR PLAN - MECHANICAL
M1.3	PART FLOOR PLANS - MECHANICAL DEMOLITION
M2.1	PART FLOOR PLANS - MECHANICAL
M2.2	PART ROOF PLAN AND DETAILS - MECHANICAL
M2.3	MECHANICAL DETAILS


ROOFTOP MAKE-UP AIR UNIT															
DRAWING REFERENCE	SERVICE	MANUFACTURER	MODEL	SUPPLY FAN					NATURAL GAS HEATING CAPACITY		ELECTRICAL			WEIGHT (LBS)	REMARKS
				AIR FLOW (CFM)	ESP (IN WG)	TSP (IN WG)	BRAKE HP	MOTOR HP	INPUT (MBH)	OUTPUT (MBH)	V/Ph/Hz	MCA	FLA		
MAU-101	KITCHEN 119	SPRING AIR SYSTEMS	SFA10-IGOH-1	1128	1	-	-	0.5	150.0	-	208/3/60	-	3.2	790	PROVIDE ROOF CURB

KITCHEN HOOD									
DRAWING REFERENCE	MANUFACTURER	MODEL	SERVICE	DIMENSIONS L x W (IN)	EXHAUST AIR VOLUME (CFM)	EXHAUST AIR PRESSURE DROP (IN WG)	COLLAR CONNECTION (IN)	WEIGHT (LBS)	REMARKS
KH-1	SPRING AIR SYSTEMS	FN-B	KITCHEN 119	72 x 47	1410	0.4	1x 14"x10"	270	LENGTH INCLUDES 12" WIDE UTILITY CABINET. PROVIDE ONE UL LISTED RECESSED ROUND LED LIGHT FIXTURE. 18GA 304 CONSTRUCTION.

detail : A - Detail number
 B - Location drawing
 C - Location drawing

date : 08/04/26 sheet :

job : 10693

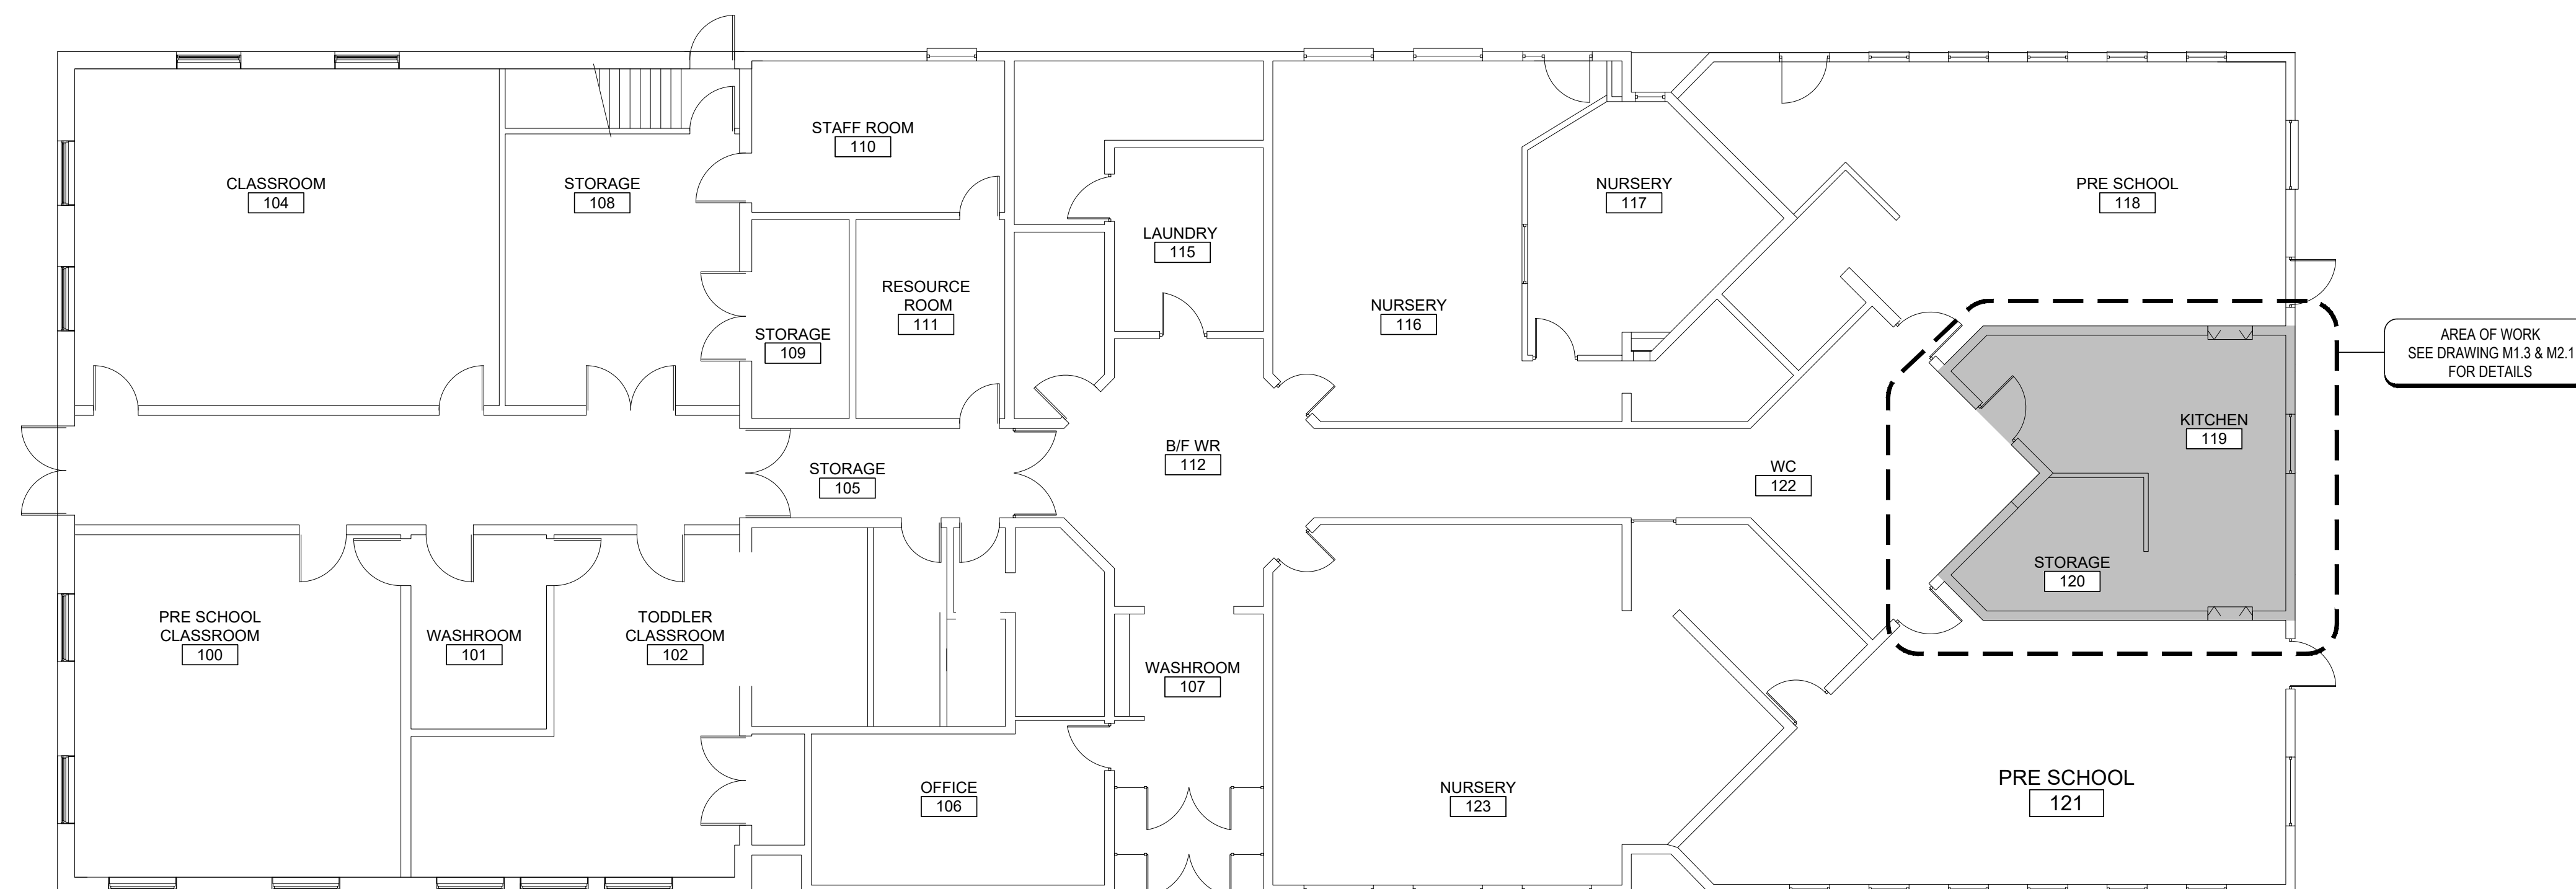


OVERALL FLOOR PLAN - MECHANICAL 

SCALE: 1/8"=1'-0"

2.	04 AUG 2026	ISSUED FOR BID
1.	29 JUL 2026	ISSUED FOR COORDINATION
Rev No.	DATE	REMARKS
ISSUED FOR		

DO NOT SCALE THE DRAWINGS. ALL MEASUREMENTS ARE TO BE CHECKED AND VERIFIED ON SITE BY THE CONTRACTOR. ANY DISCREPANCIES ARE TO BE REPORTED TO THE CONSULTANT BEFORE PROCEEDING WITH THE WORK.

COPYRIGHT © ALL RIGHTS RESERVED. ALL DRAWINGS AND RELATED DOCUMENTS ARE THE COPYRIGHT OF THE CONSULTANT AND MUST BE RETURNED UPON REQUEST OR AT THE COMPLETION OF THE WORK. REPRODUCTION OF THESE DRAWINGS OR RELATED DOCUMENTS IN PART OR IN WHOLE, BY ELECTRONIC OR MECHANICAL MEANS, IS FORBIDDEN BY LAW WITHOUT THE PRIOR WRITTEN PERMISSION OF THE CONSULTANT.

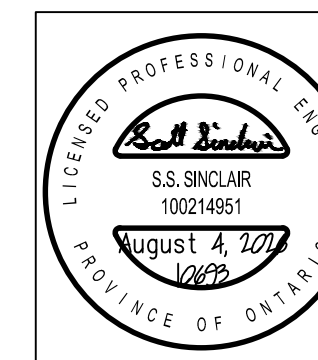

376 Cambridge Street,
Goderich, ON

OVERALL FLOOR PLAN MECHANICAL

scale : **AS NOTED**



0

detail : A - Detail number
 B - Location drawing
 C - Location drawing

drawn : BCF check : BCF

date : 08/04/26 sheet :


job : 10693

M1.2




201 QUEENS AVE., UNIT 800
LONDON ON, N6A 1J1

250 CITY CENTRE AVE., SUITE 403
OTTAWA ON, K1R 6K7

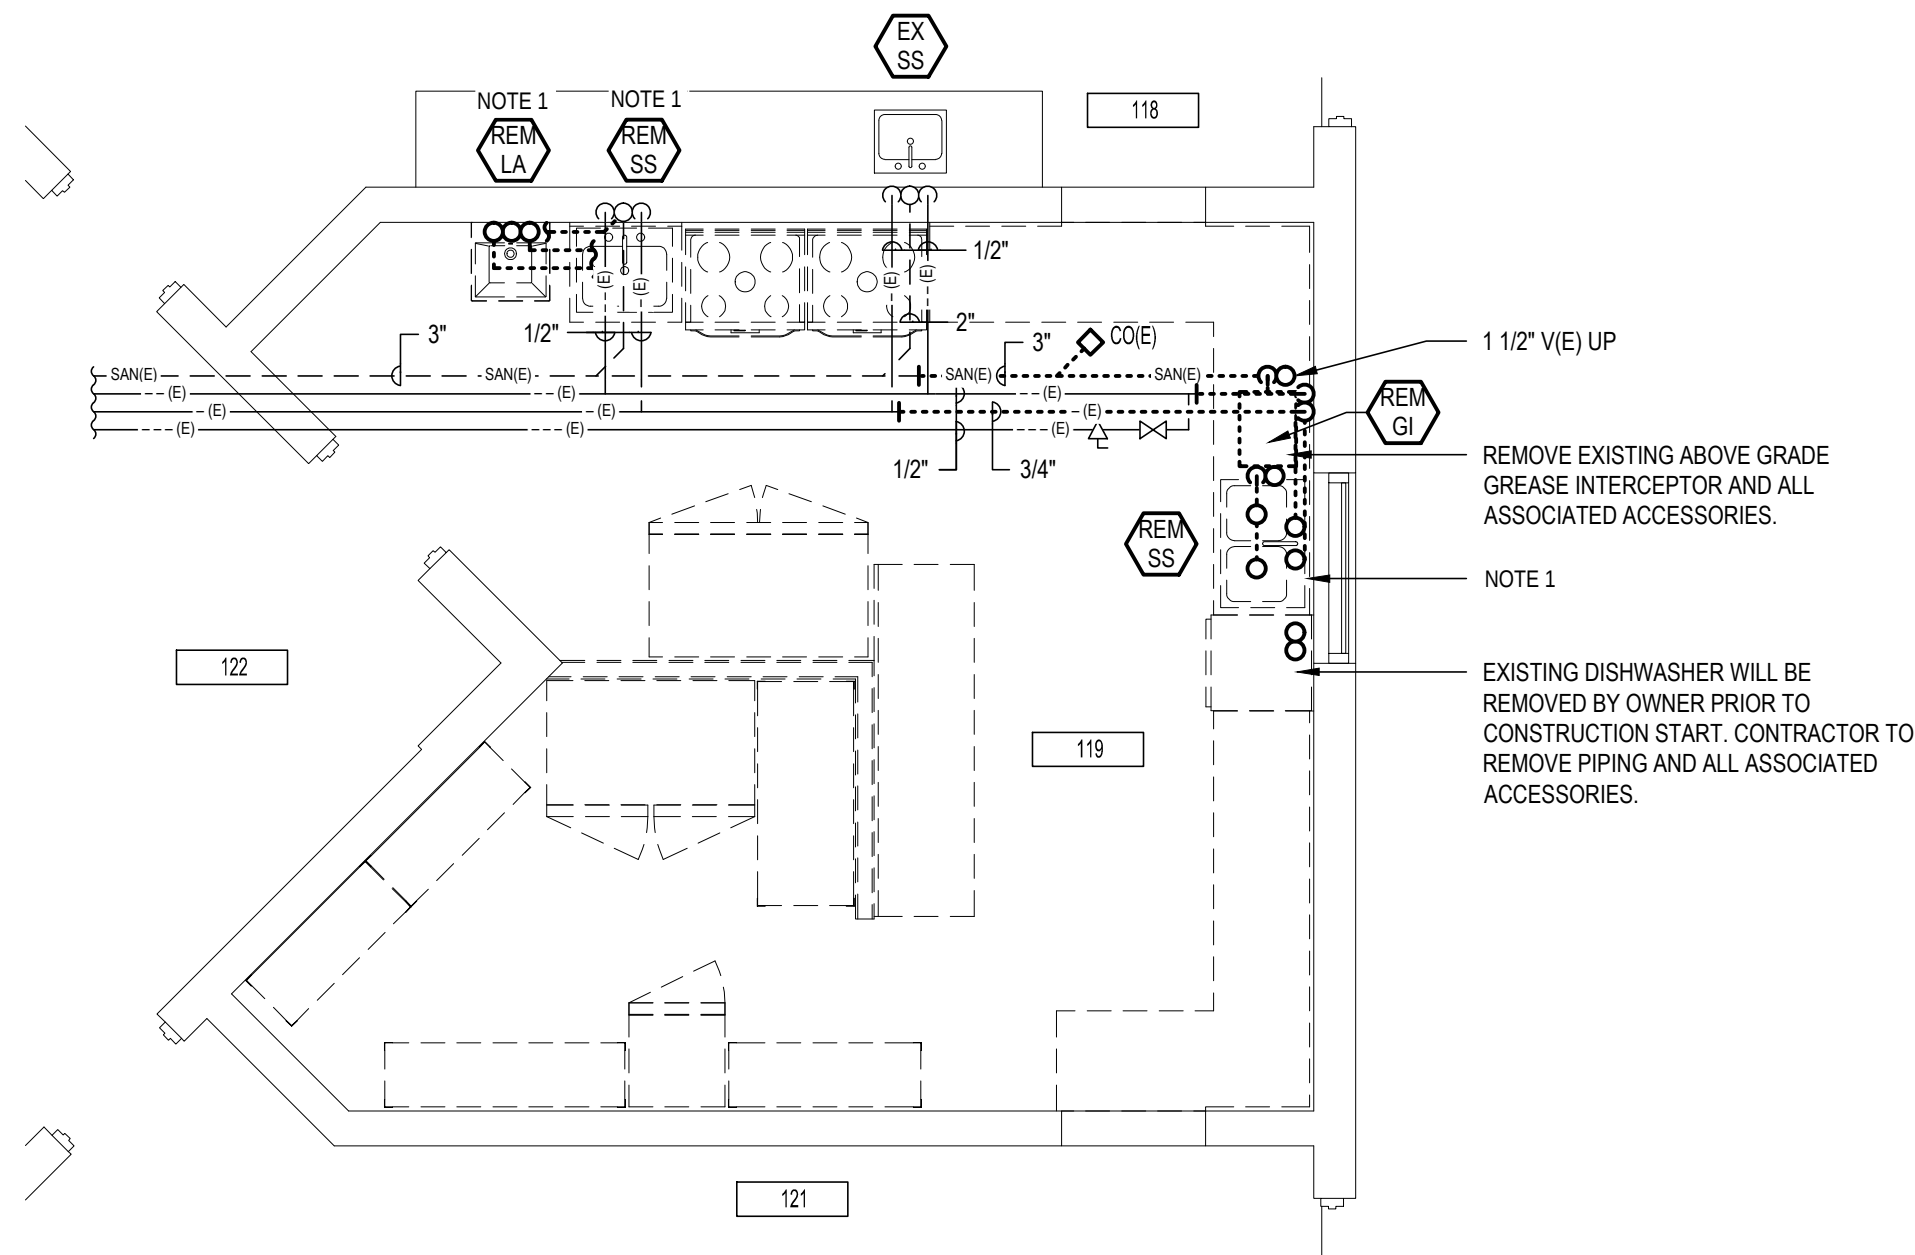


PART FLOOR PLAN - PLUMBING DEMOLITION
SCALE: 1/4"=1'-0"

- NOTES:
1. REMOVE EXISTING SINK AND TURN OVER TO OWNER. REMOVE AND DISPOSE OF HW/CW AND SAN PIPING AND ALL ASSOCIATED ACCESSORIES.
 2. ALL EXISTING FOOD SERVICE EQUIPMENT WILL BE REMOVED BY OWNER PRIOR TO START OF CONSTRUCTION.
 3. EXISTING CW/HW TO BE ABANDONED. CAP PIPING AT MAIN IN CEILING. ENSURE THERE ARE NO DEAD LEGS OF PIPING.

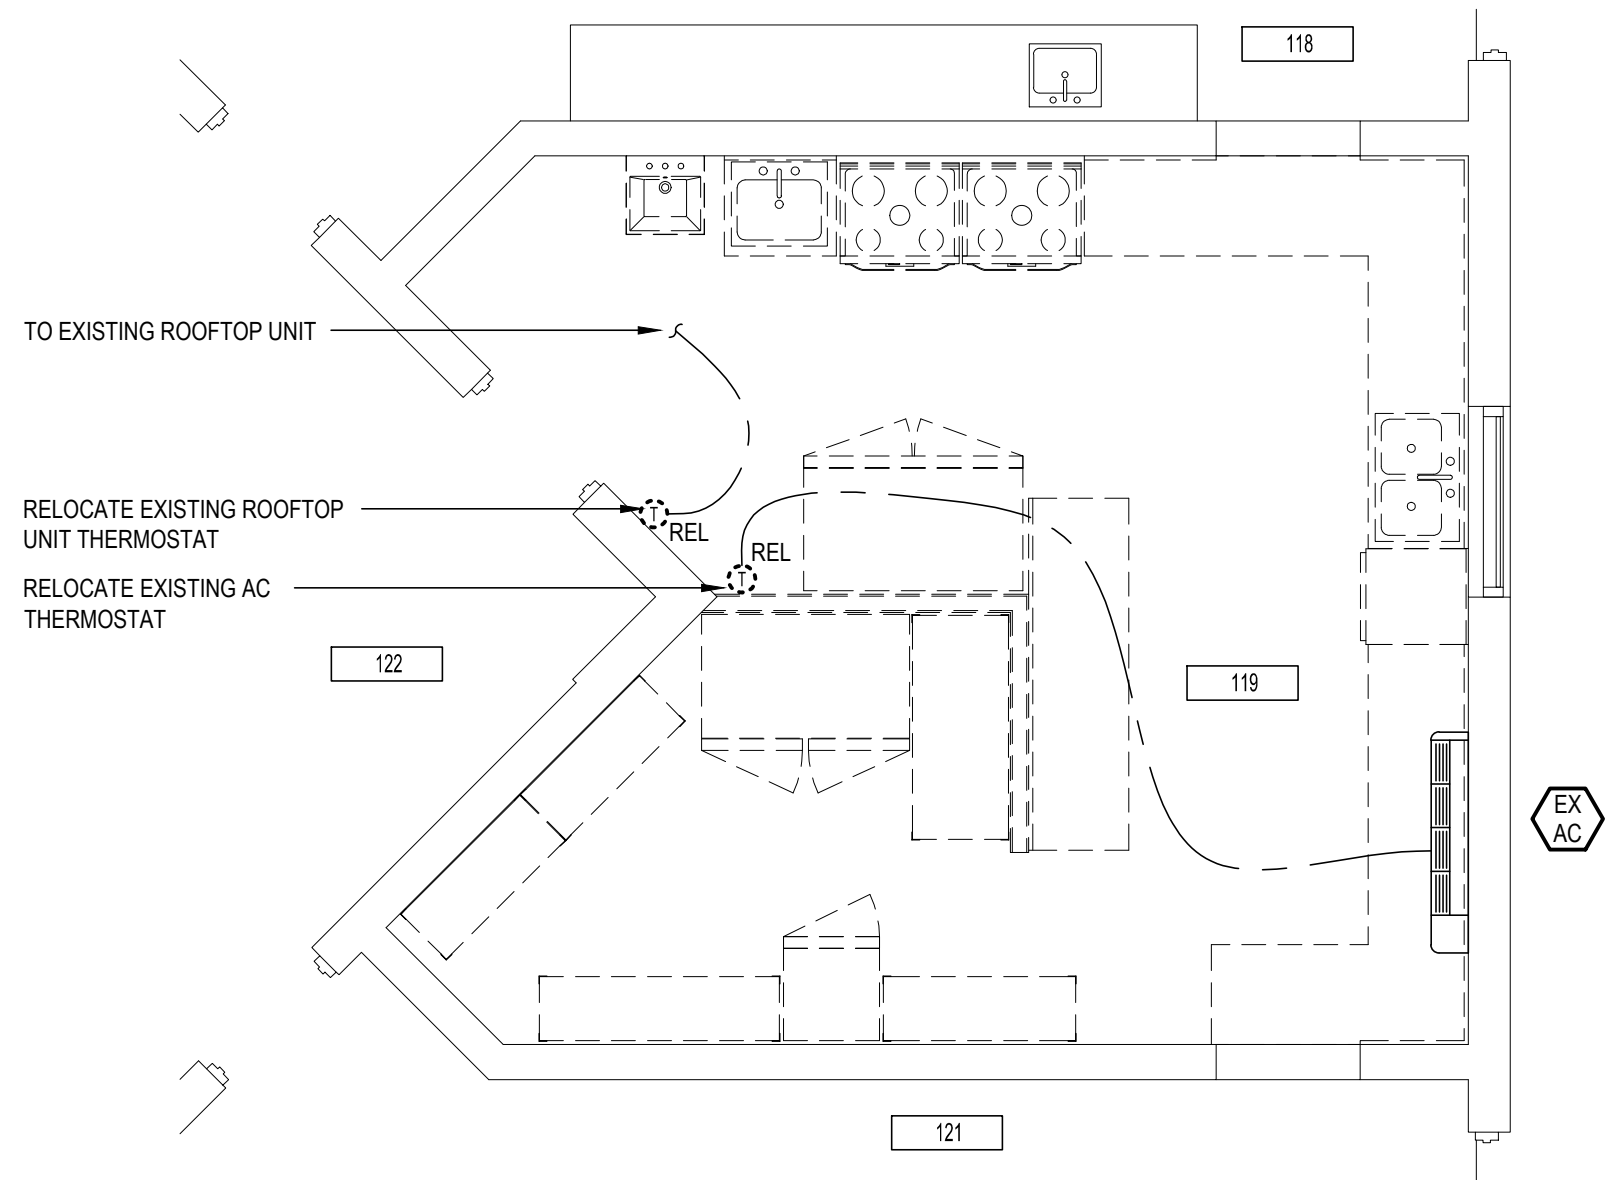

PART FLOOR PLAN - HEATING DEMOLITION
SCALE: 1/4"=1'-0"

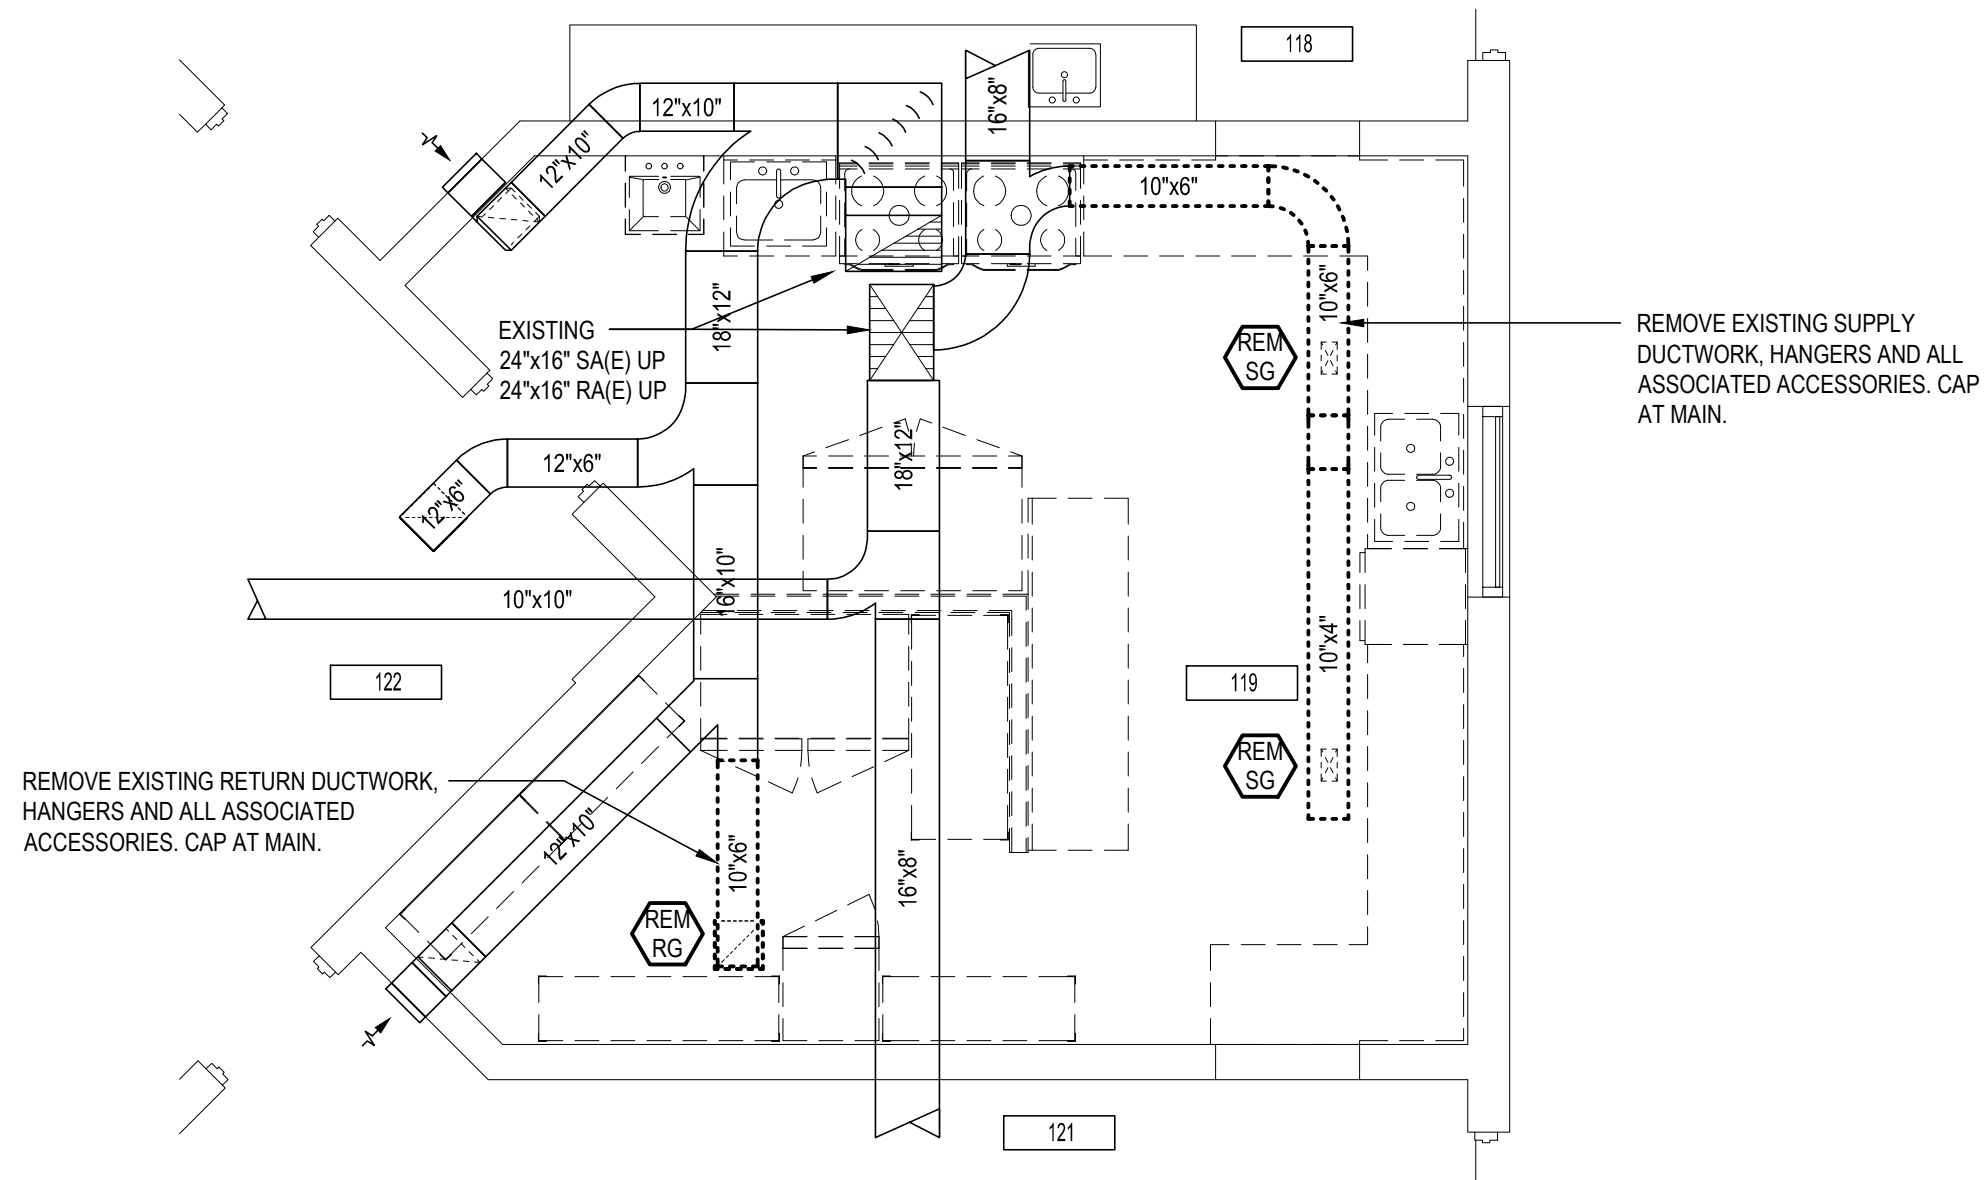

PART FLOOR PLAN - AIR DISTRIBUTION DEMOLITION
SCALE: 1/4"=1'-0"

Rev No.	DATE	REMARKS
2.	04 AUG 2026	ISSUED FOR BID
1.	29 JUL 2026	ISSUED FOR COORDINATION

ISSUED FOR

DO NOT SCALE THE DRAWINGS. ALL MEASUREMENTS ARE TO BE CHECKED AND VERIFIED ON SITE BY THE CONTRACTOR. ANY DISCREPANCIES ARE TO BE REPORTED TO THE CONSULTANT BEFORE PROCEEDING WITH THE WORK.

COPYRIGHT © ALL RIGHTS RESERVED. ALL DRAWINGS AND RELATED DOCUMENTS ARE THE COPYRIGHT OF THE CONSULTANT AND MUST BE RETURNED UPON REQUEST OR AT THE COMPLETION OF THE WORK. REPRODUCTION OF THESE DRAWINGS OR RELATED DOCUMENTS IN PART OR IN WHOLE, BY ELECTRONIC OR MECHANICAL MEANS, IS FORBIDDEN BY LAW WITHOUT THE PRIOR WRITTEN PERMISSION OF THE CONSULTANT.



**Municipal Child Care Centre
Kitchen Renovation**

376 Cambridge Street,
Goderich, ON

**PART FLOOR PLANS
MECHANICAL DEMOLITION**

scale : **AS NOTED**

detail : A - Detail number
B - Location drawing
C - Location drawing

A
B
C


drawn : BCF
check : BCF

date : 08/04/26
sheet :

job : 10693
M1.3

PROVIDE 2" SANITARY ROUGH IN FOR DISHWASHER.

INSTALL 1 1/4" SANITARY FOR SS1 HORIZONTALLY WITHIN PLUMBING WALL.

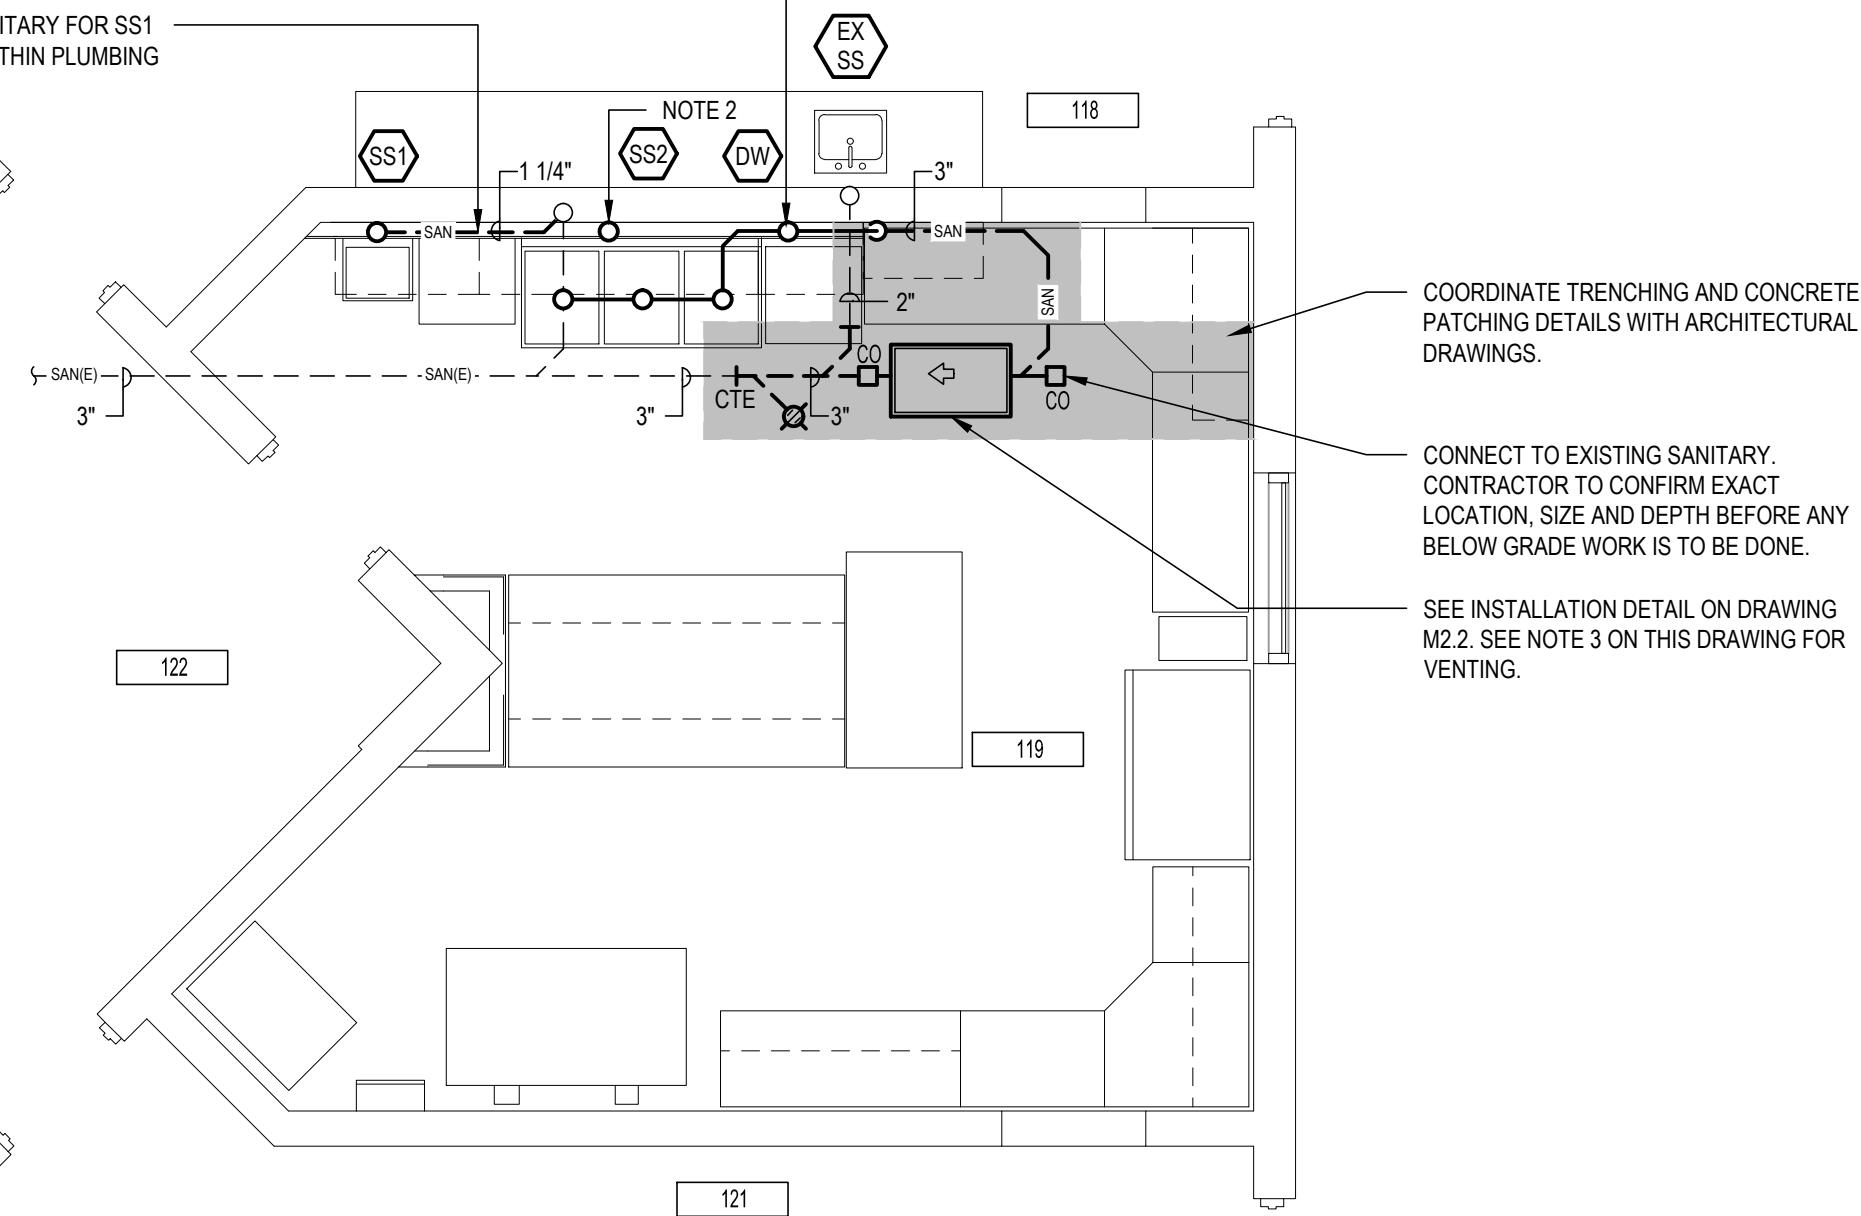**PART FLOOR PLAN - DRAINAGE**


SCALE: 1/4"=1'-0"

NOTES:

1. MINIMUM BELOW GRADE PIPING IS 3".
2. PROVIDE NEW VENT FOR ALL FIXTURES. EXACT LOCATION TO BE CONFIRMED ON SITE. VENT IN ACCORDANCE WITH OBC.
3. PROVIDE NEW VENT FOR THE GREASE INTERCEPTOR AND CONNECT TO NEAREST EXISTING SANITARY VENT WITH CAPACITY IN THE CEILING SPACE OF THIS KITCHEN. EXACT LOCATION TO BE CONFIRMED ON SITE. VENT IN ACCORDANCE WITH OBC.

PROVIDE 1/2" HW ROUGH IN FOR DISHWASHER.

NEATLY INSTALL 1/2" HW/CW FOR SS1 HORIZONTALLY WITHIN PLUMBING WALL.

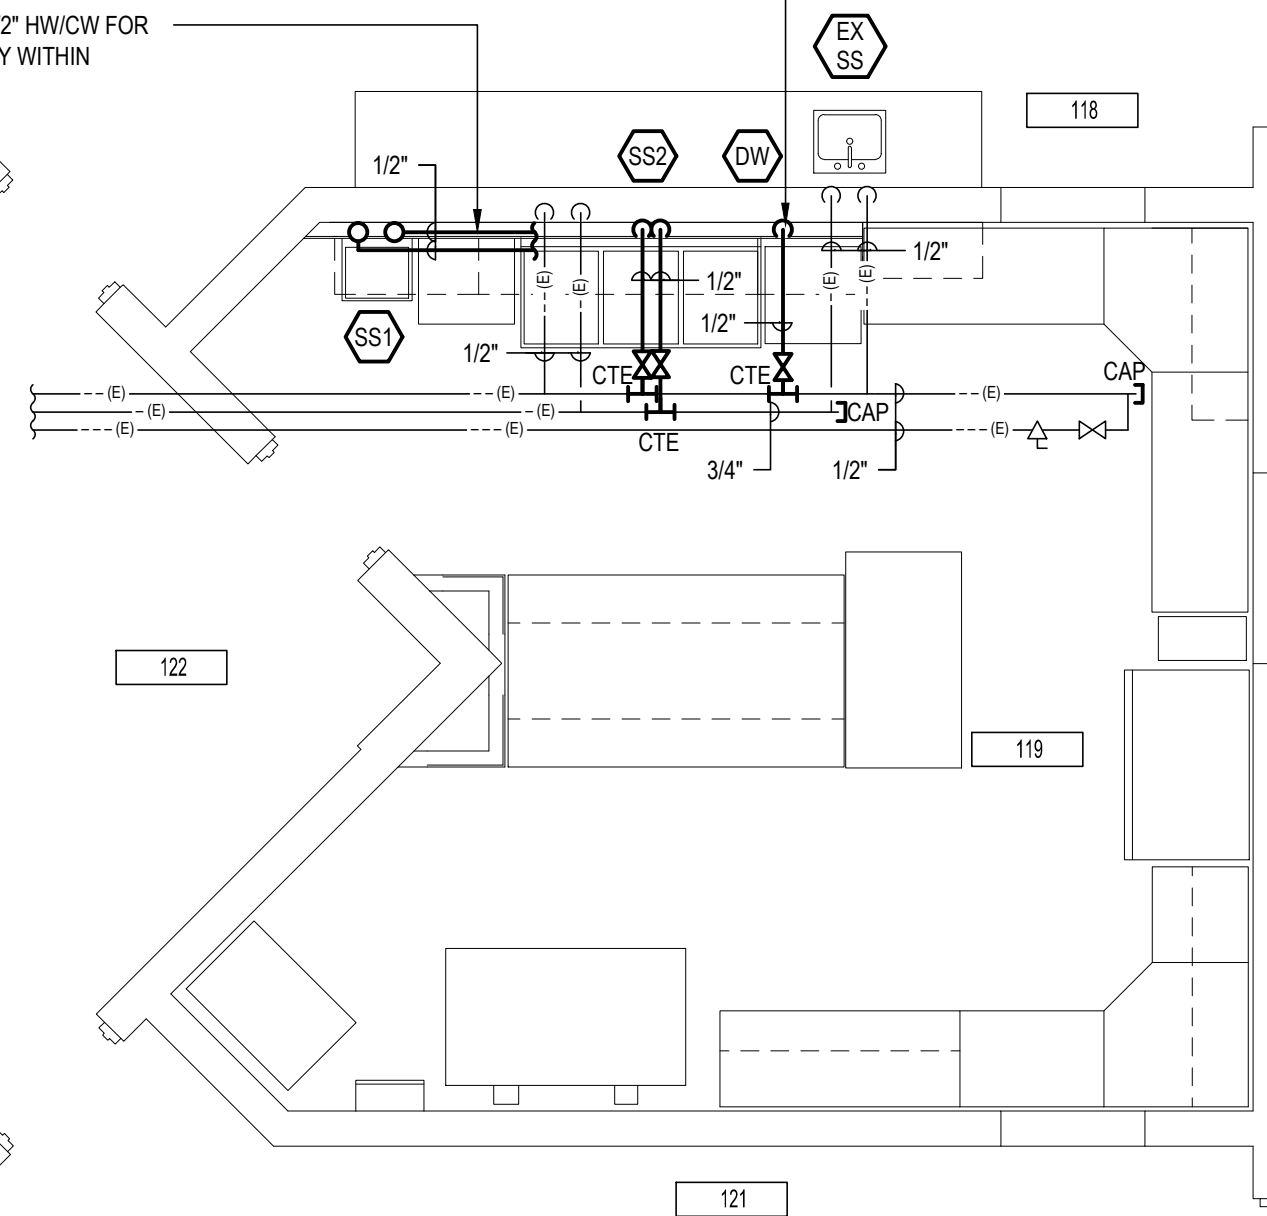
**PART FLOOR PLAN - PLUMBING**

SCALE: 1/4"=1'-0"

TO EXISTING ROOFTOP UNIT


RELOCATE EXISTING ROOFTOP UNIT THERMOSTAT

RELOCATE EXISTING AC THERMOSTAT

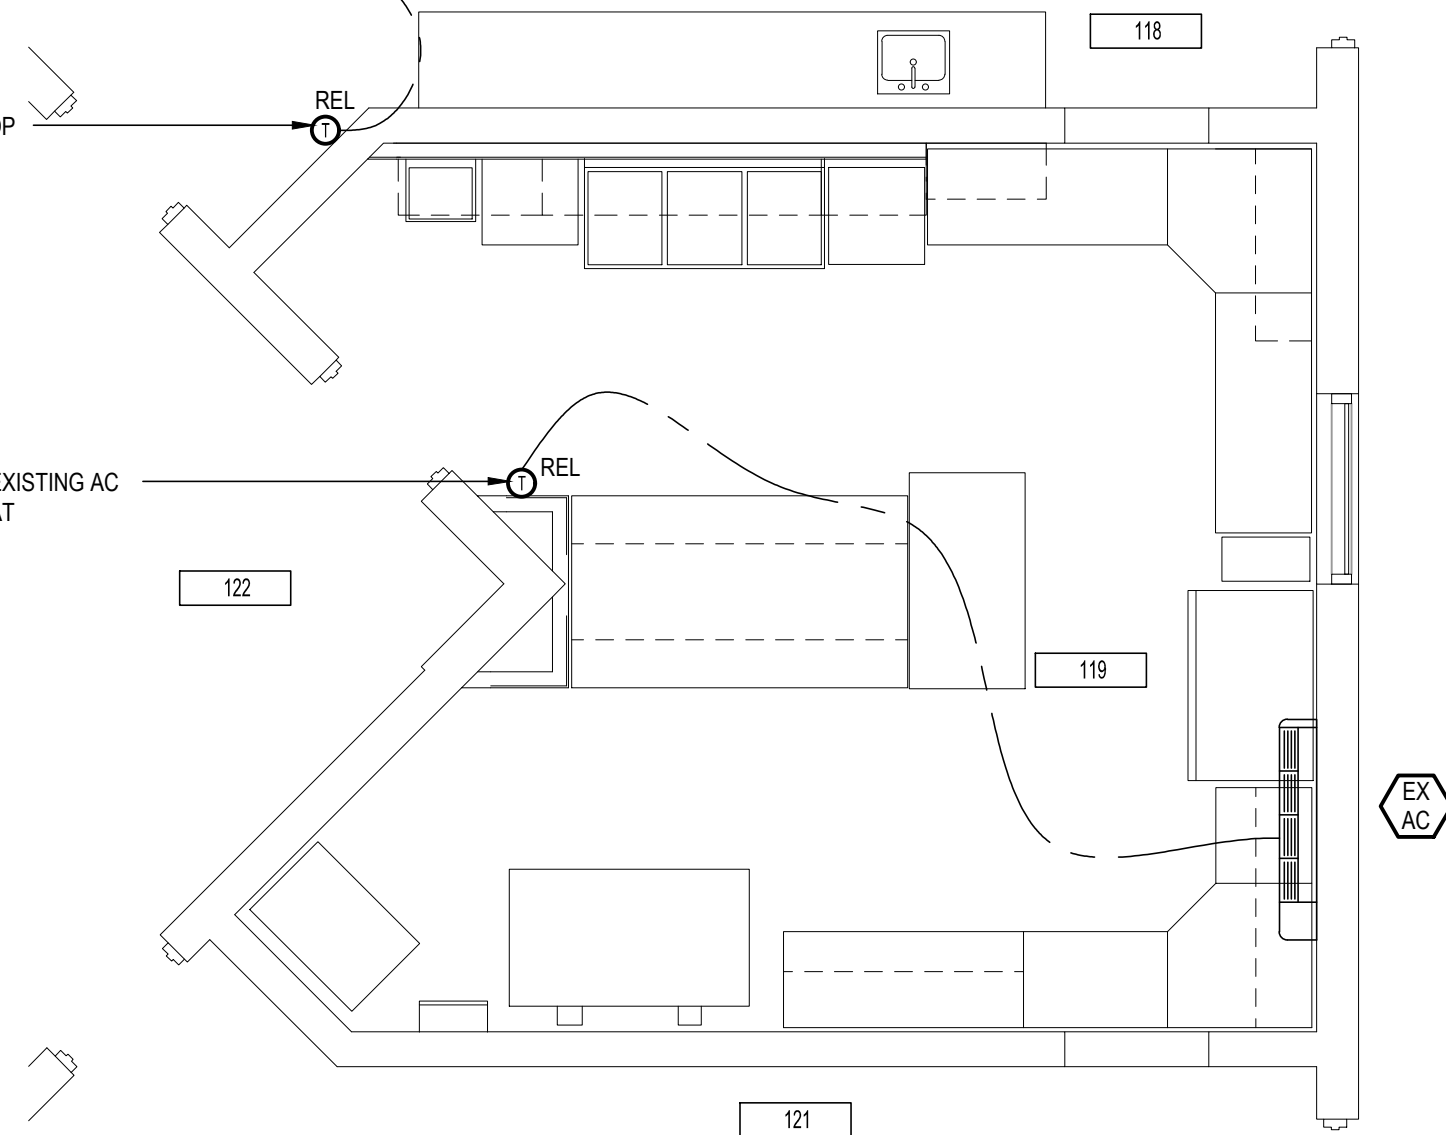**PART FLOOR PLAN - HEATING**

SCALE: 1/4"=1'-0"

14"x10" HOOD CONNECTION. TRANSITION TO 14"x14" THROUGH ROOF TO NEW EF-1. SEE DETAIL ON DRAWING M2.2

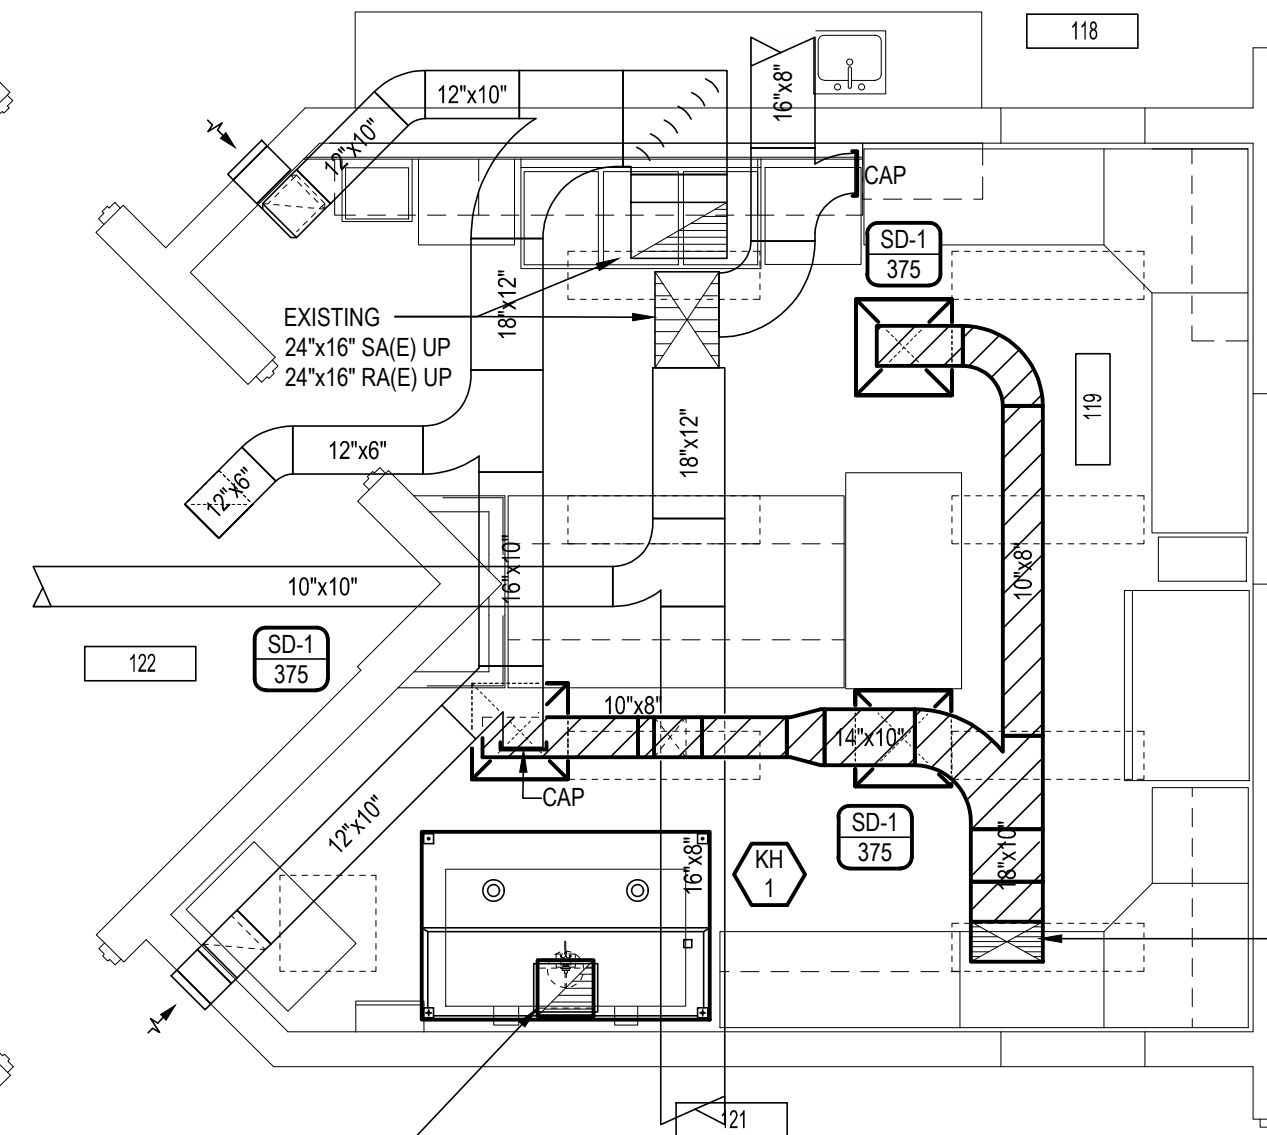**PART FLOOR PLAN - AIR DISTRIBUTION**

SCALE: 1/4"=1'-0"

INSULATED 18"x10" S.A. DUCT UP TO MUA-101 ON ROOF. REFER TO DRAWING M2.2 FOR CONTINUATION.

Chorley + Bisset
CONSULTING ENGINEERS
chorley.com

201 QUEENS AVE., UNIT 800
LONDON ON, N6A 1J1

250 CITY CENTRE AVE., SUITE 403
OTTAWA ON, K1R 6K7

Rev No.	DATE	REMARKS
1.	29 JUL 2026	ISSUED FOR COORDINATION
2.	04 AUG 2026	ISSUED FOR BID

ISSUED FOR

DO NOT SCALE THE DRAWINGS. ALL MEASUREMENTS ARE TO BE CHECKED AND VERIFIED ON SITE BY THE CONTRACTOR. ANY DISCREPANCIES ARE TO BE REPORTED TO THE CONSULTANT BEFORE PROCEEDING WITH THE WORK.

COPYRIGHT © ALL RIGHTS RESERVED. ALL DRAWINGS AND RELATED DOCUMENTS ARE THE COPYRIGHT OF THE CONSULTANT AND MUST BE RETURNED UPON REQUEST OR AT THE COMPLETION OF THE WORK. REPRODUCTION OF THESE DRAWINGS OR RELATED DOCUMENTS IN PART OR IN WHOLE, BY ELECTRONIC OR MECHANICAL MEANS, IS FORBIDDEN BY LAW WITHOUT THE PRIOR WRITTEN PERMISSION OF THE CONSULTANT



Municipal Child Care Centre Kitchen Renovation

376 Cambridge Street,
Goderich, ON

PART FLOOR PLANS MECHANICAL

scale : **AS NOTED**

detail : A - Detail number
B - Location drawing
C - Location drawing

drawn : BCF


check : BCF

date : 08/04/26

sheet :

job : 10693

M2.1

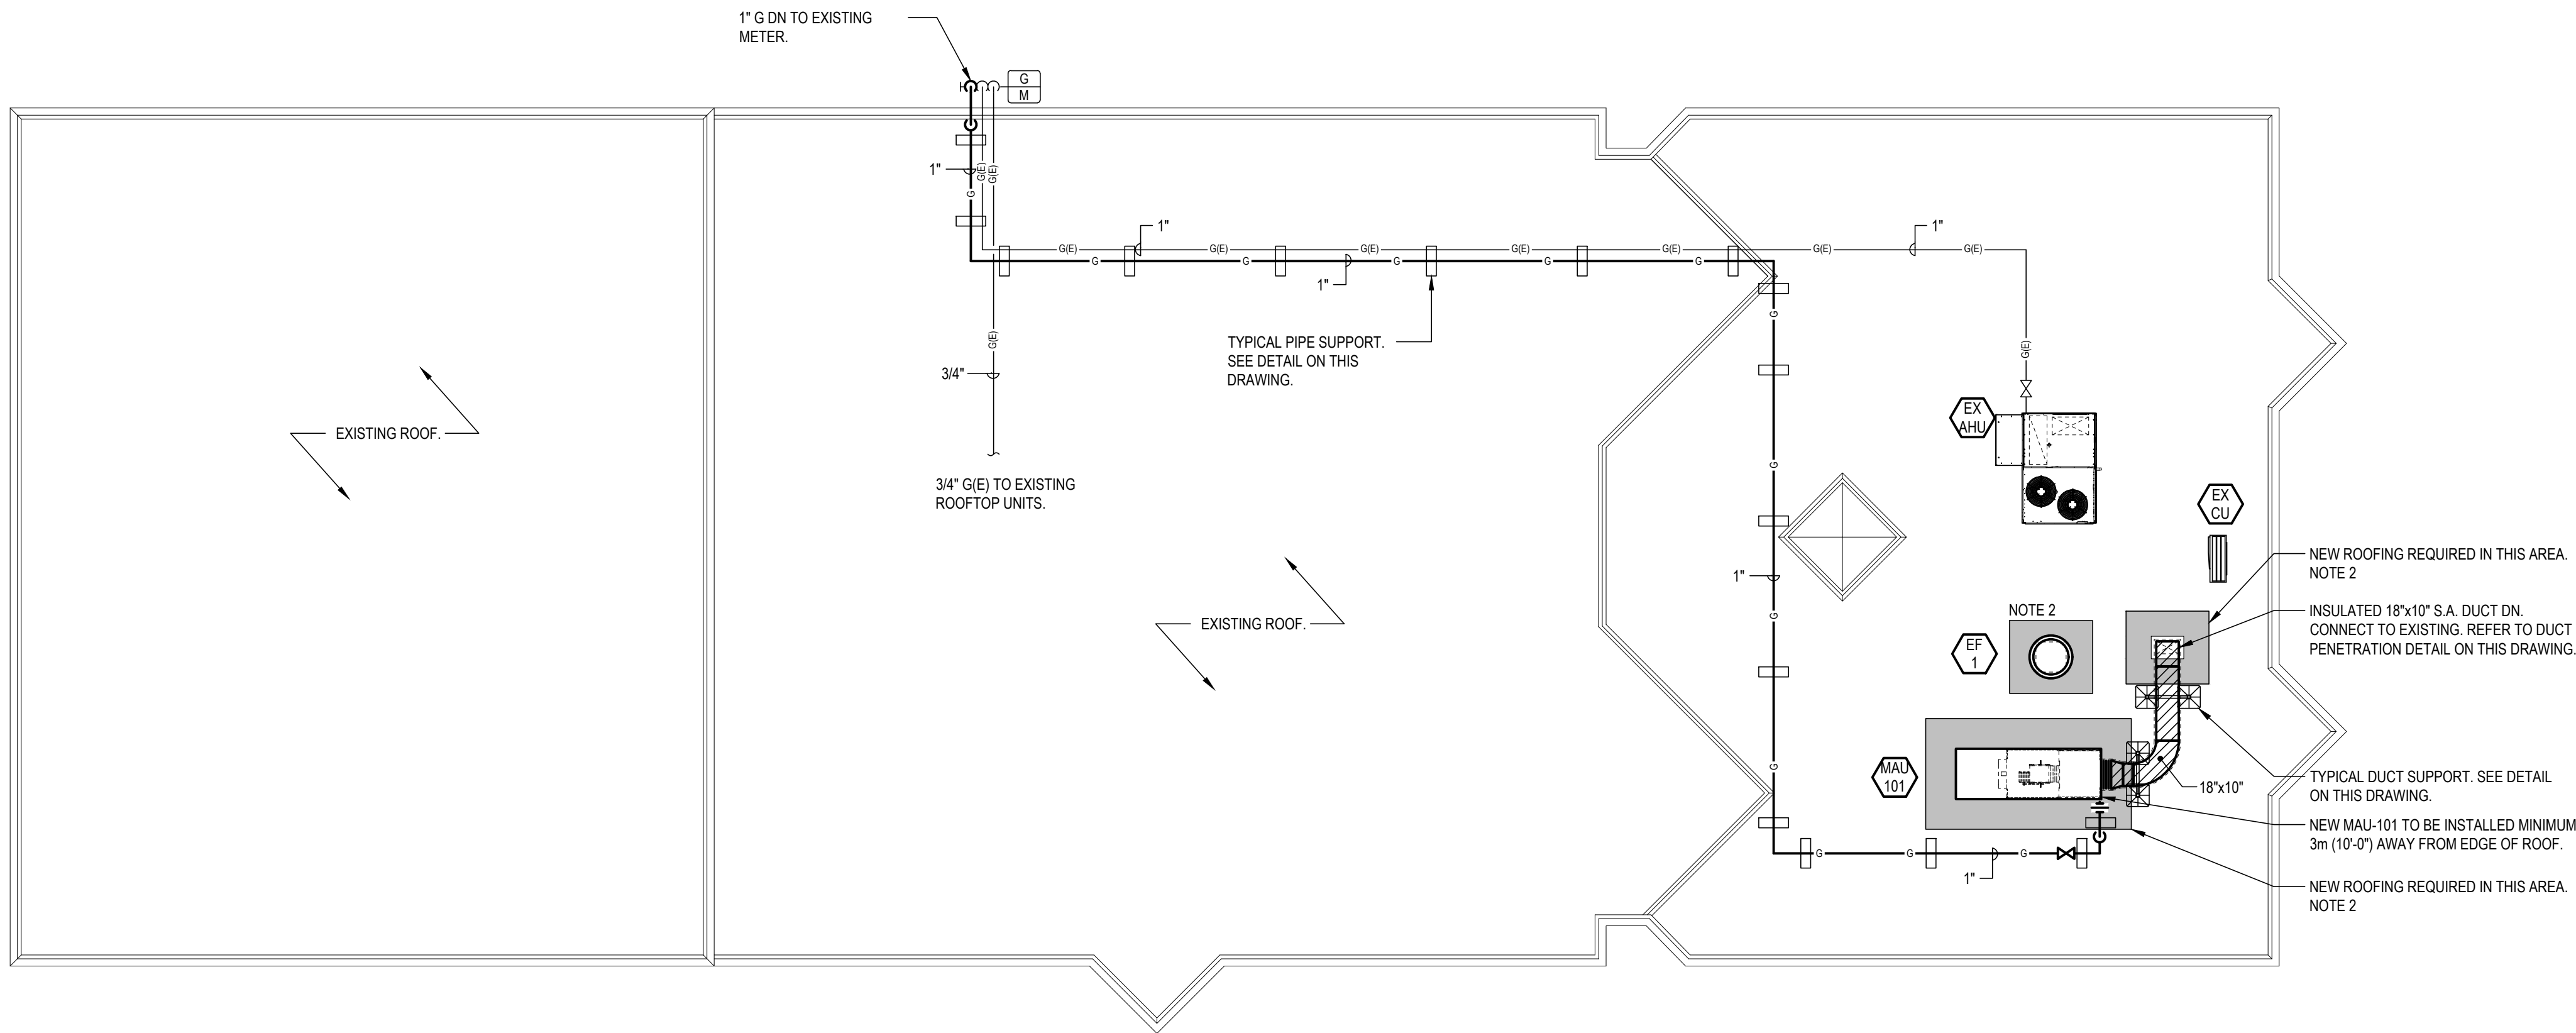


ROOF PLAN - MECHANICAL

SCALE: 1/8"=1'-0"

NOTES:

1. PROVIDE A 600x600 PRECAST CONCRETE PAVER AT EACH EXTERNAL DRAIN CONNECTION ON THE UNIT. PROVIDE 450x450x50 MM THICKNESS RIGID INSULATION BELOW PAVER. PROVIDE CPVC PIPING AND P TRAP FOR EACH DRAIN IN ACCORDANCE WITH UNIT MANUFACTURER'S RECOMMENDATIONS. ARRANGE DRAIN TO DISCHARGE ON TO PAVER.
2. SHADED AREAS DENOTE REQUIRED ROOF REPAIR AREA. REFER TO ARCHITECTURAL DRAWINGS. REFER TO ARCHITECTURAL SPECIFICATIONS FOR STRUCTURAL ROOF REINFORCEMENT DETAILS.
3. PAINT ALL NEW GAS PIPING AND VALVES YELLOW, TWO COATS.
4. RUN NEW GAS PIPING WHILE EXISTING CONTINUES TO OPERATE.
5. CONTRACTOR TO SHUT DOWN ALL GAS FIRED EQUIPMENT AFFECTED FOR ANY GAS SERVICE DISRUPTIONS OR SHUT DOWNS. RE-START ALL EQUIPMENT AFTER GAS SERVICES IS TURNED BACK ON.
6. REFER TO ARCHITECTURAL DRAWINGS FOR MAU-101 ROOF CURB DETAIL.

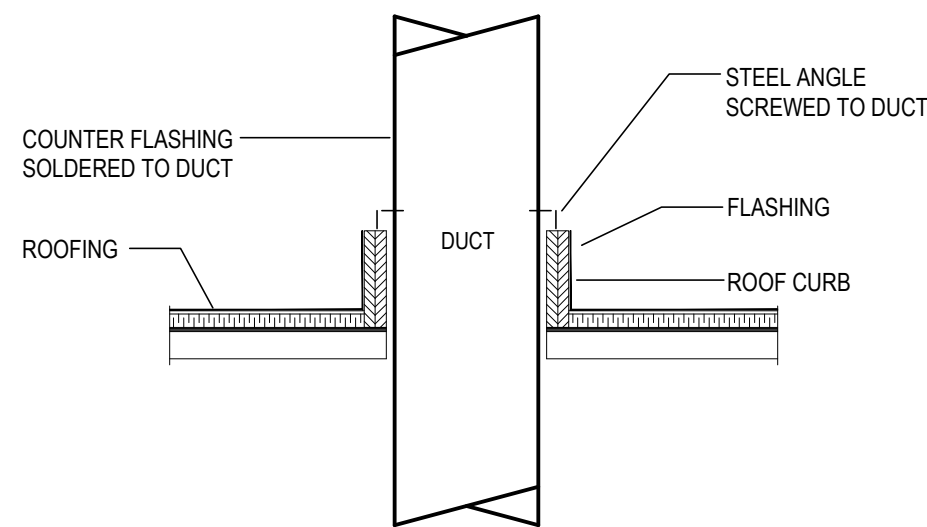


TYPICAL DUCT DETAIL THROUGH ROOF

N.T.S.

NOTE:

1. SEE ARCHITECTURAL DRAWINGS FOR ROOF DETAILS.

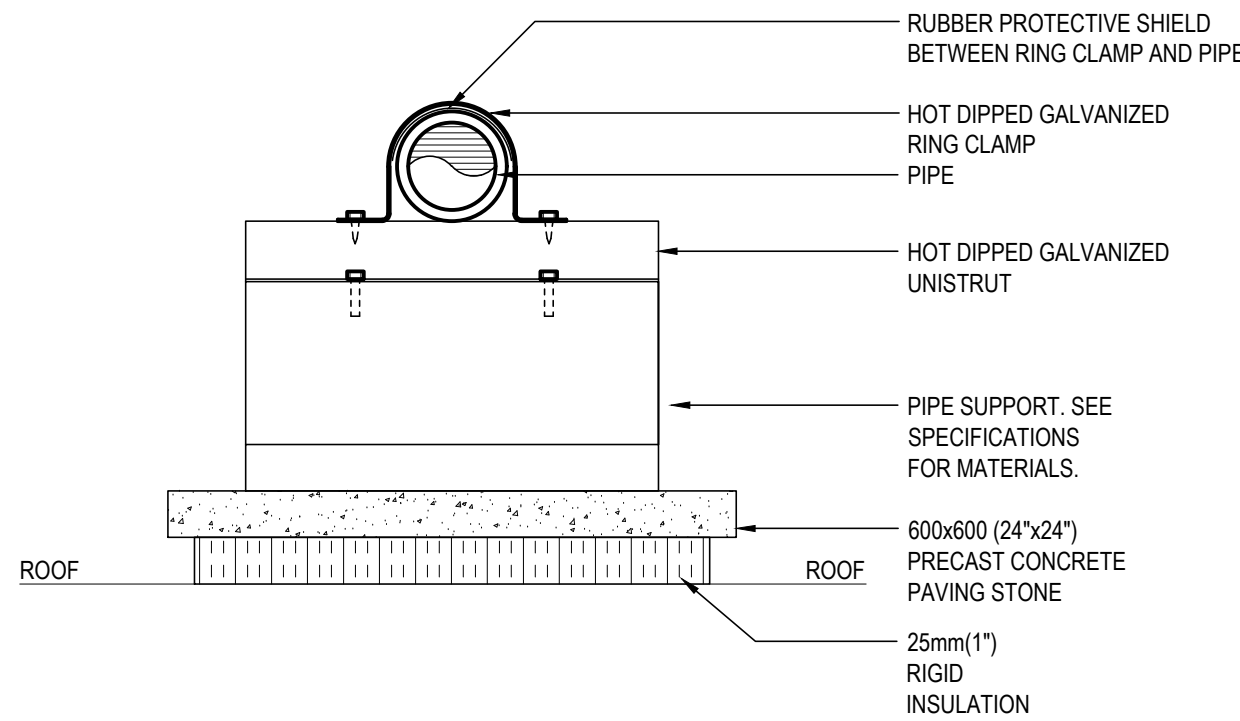


ROOFTOP PIPE SUPPORT DETAIL

N.T.S.


NOTE:

1. PROVIDE ROOFTOP SUPPORT FOR GAS PIPING AT EACH CHANGE IN DIRECTION AND ON MAX 3M (10'-0") CENTRES.
2. PROVIDE HEIGHT EXTENSION, BLOCK EXTENSION RODS, PIPE ROLLERS, SECURING BRACKET ACCESSORIES AS REQUIRED TO SUIT INSTALLATION.

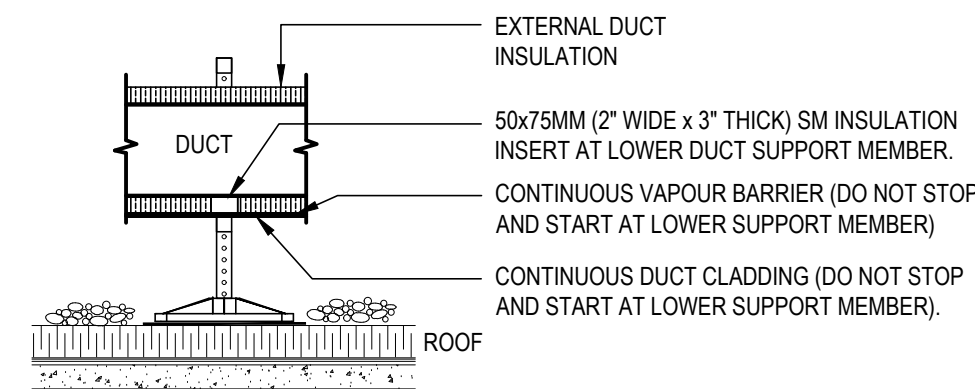

SECTION A-A

N.T.S.

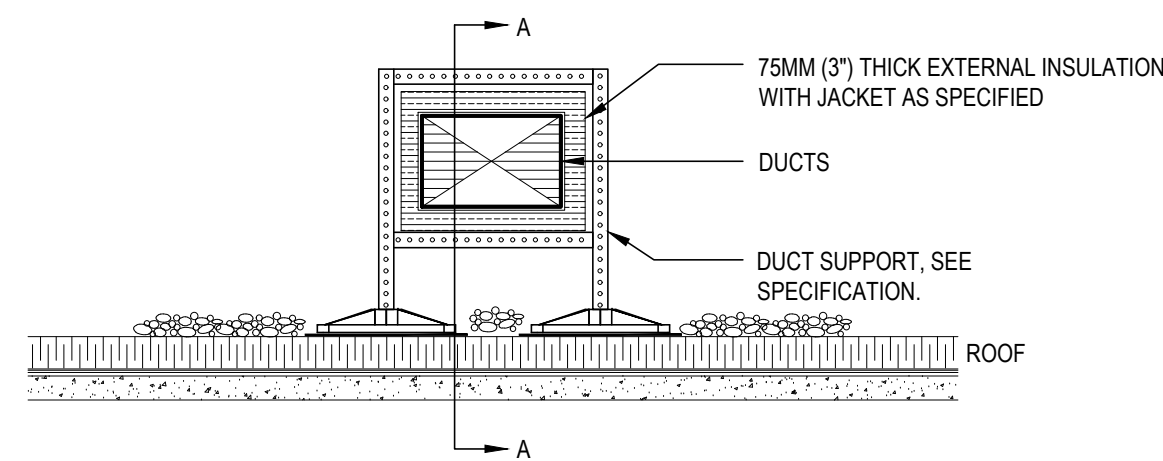

DUCT SUPPORT DETAIL

N.T.S.



201 QUEENS AVE., UNIT 800
LONDON ON, N6A 1J1

250 CITY CENTRE AVE., SUITE 403
OTTAWA ON, K1R 6K7

Rev No.	DATE	REMARKS
2.	04 AUG 2026	ISSUED FOR BID
1.	29 JUL 2026	ISSUED FOR COORDINATION

ISSUED FOR

DO NOT SCALE THE DRAWINGS. ALL MEASUREMENTS ARE TO BE CHECKED AND VERIFIED ON SITE BY THE CONTRACTOR. ANY DISCREPANCIES ARE TO BE REPORTED TO THE CONSULTANT BEFORE PROCEEDING WITH THE WORK.


COPYRIGHT © ALL RIGHTS RESERVED. ALL DRAWINGS AND RELATED DOCUMENTS ARE THE COPYRIGHT OF THE CONSULTANT AND MUST BE RETURNED UPON REQUEST OR AT THE COMPLETION OF THE WORK. REPRODUCTION OF THESE DRAWINGS OR RELATED DOCUMENTS IN PART OR IN WHOLE, BY ELECTRONIC OR MECHANICAL MEANS, IS FORBIDDEN BY LAW WITHOUT THE PRIOR WRITTEN PERMISSION OF THE CONSULTANT



Municipal Child Care Centre Kitchen Renovation

376 Cambridge Street,
Goderich, ON

PART ROOF PLAN AND DETAILS MECHANICAL


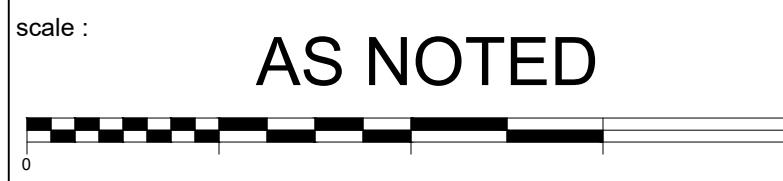


detail :	A - Detail number B - Location drawing C - Location drawing	A B C
----------	---	--------------------------


drawn :	BCF	check :	BCF
---------	-----	---------	-----

date :	08/04/26	sheet :	M2.2
--------	----------	---------	------

job :	10693
-------	-------

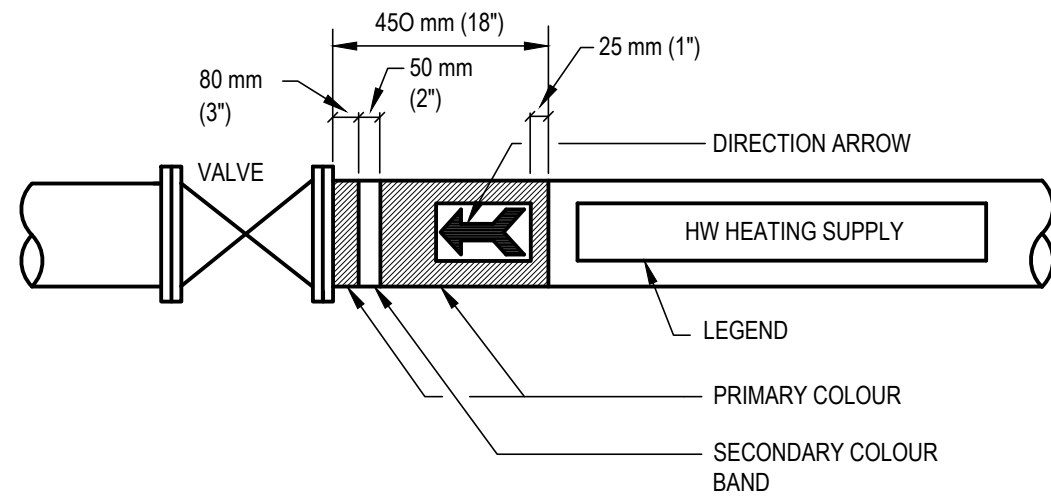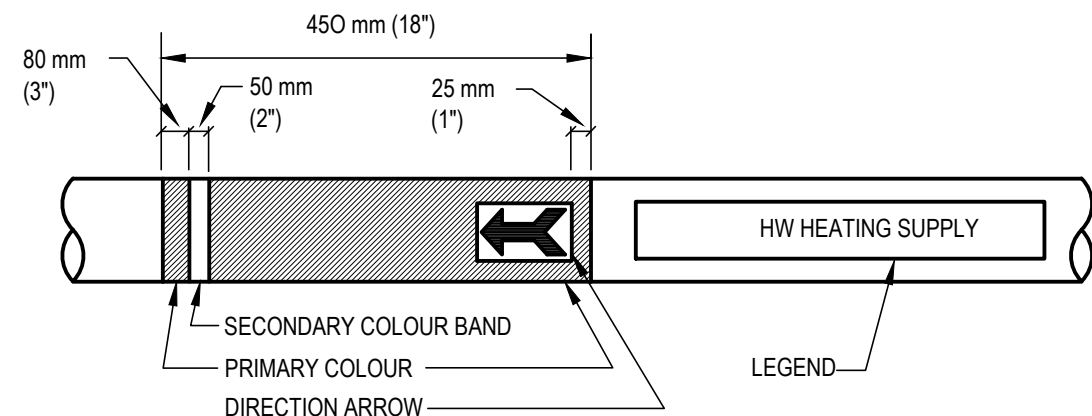


IDENTIFICATION OF PIPING SYSTEMS
N.T.S.

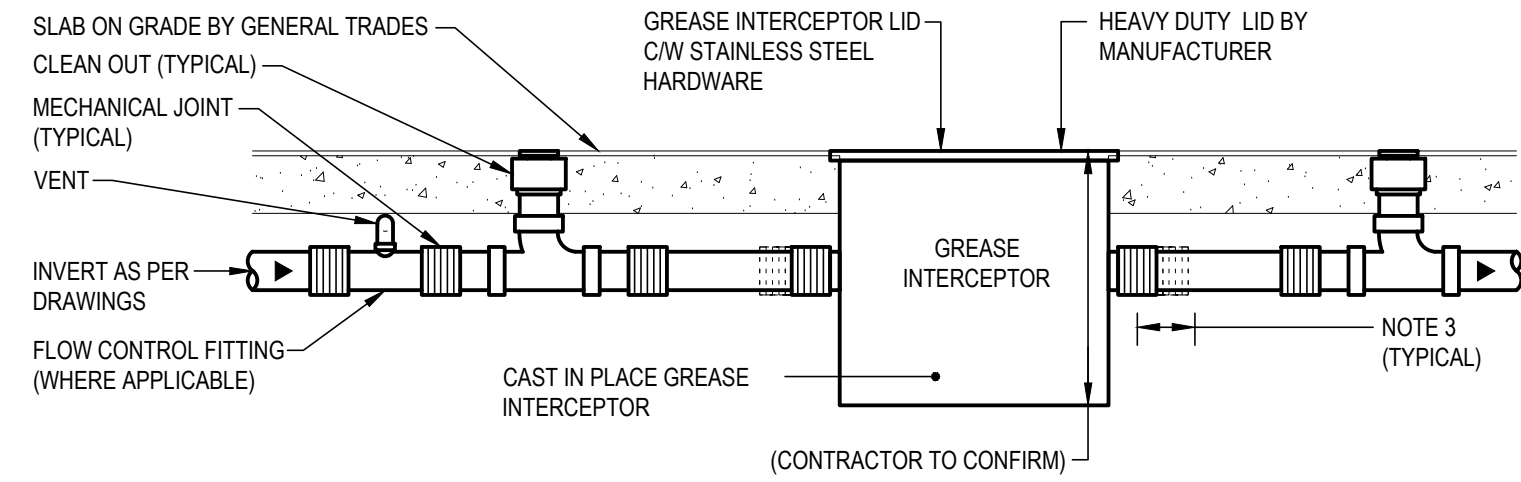

GREASE INTERCEPTOR INSTALLATION DETAIL
N.T.S.

NOTES:

- COORDINATE GREASE INTERCEPTOR INSTALLATION INVERT WITH ESTIMATED SANITARY DRAINAGE INVERTS AT THE INLET AND OUTLET OF GREASE INTERCEPTOR.

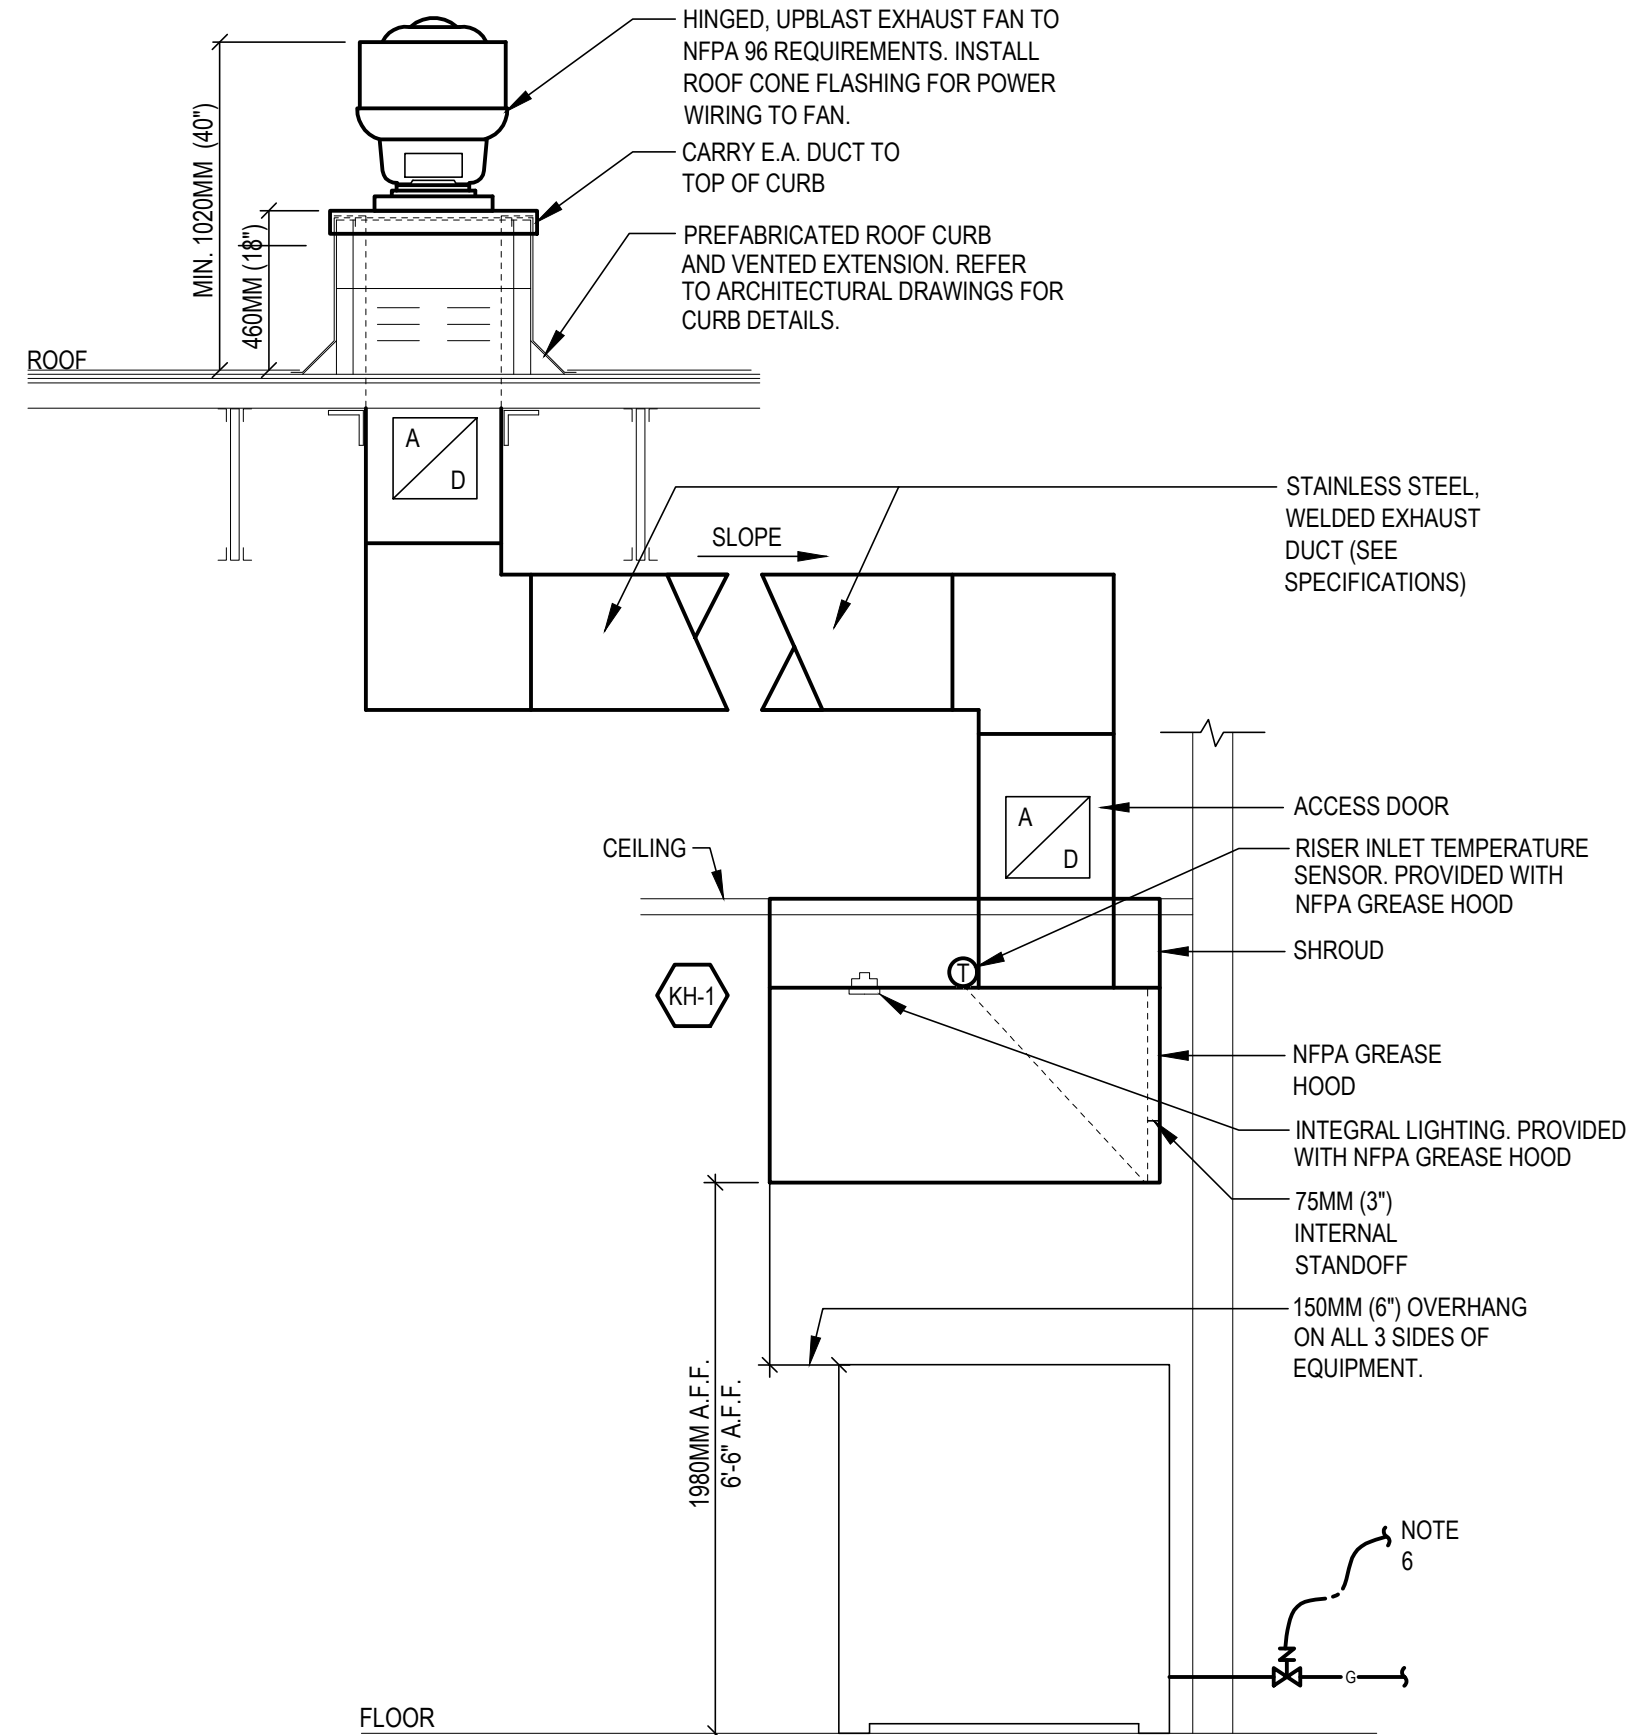



TYPICAL NFPA EXHAUST DETAIL

N.T.S.

NOTES:

- KITCHEN HOOD EXHAUST DUCTS TO HAVE ACCESS DOORS WITH LABELS AND SIGNAGE AS REQUIRED BY NFPA 96.
- MAINTAIN 75MM (3") CLEARANCE AROUND KITCHEN HOOD EXHAUST DUCTS FROM ALL LIMITED COMBUSTIBLE MATERIALS AS REQUIRED BY NFPA 96.
- MAINTAIN 450MM CLEARANCE AROUND KITCHEN EXHAUST DUCTS FROM ALL COMBUSTIBLE MATERIALS AS REQUIRED BY NFPA 96.
- WHERE CLEARANCES FROM COMBUSTIBLE MATERIAL IS NOT ACHIEVABLE, INSTALL USING ANY OF THE CLEARANCE REDUCTION METHODS ACCEPTED BY THE LATEST VERSION OF NFPA 96.
- KITCHEN SUPPRESSION AND EXHAUST SYSTEM TO BE INSTALLED IN ACCORDANCE WITH NFPA 96-11 AND 17A.
- PROVIDE 120V, N.C., ASCO SERIES 8040 GAS SOLENOID VALVE INTERLOCKED WITH ELECTRICAL CONTACT 'C2'. REFER TO ELECTRICAL DRAWINGS DETAIL KITCHEN HOOD STARTER SCHEMATIC.

KEY	
	ACCESS DOOR
	CONDENSER SECTION
	DIX COOLING COIL
	FILTER
	HEAT EXCHANGER
	OUTSIDE AIR DAMPER
	SUPPLY AIR FAN

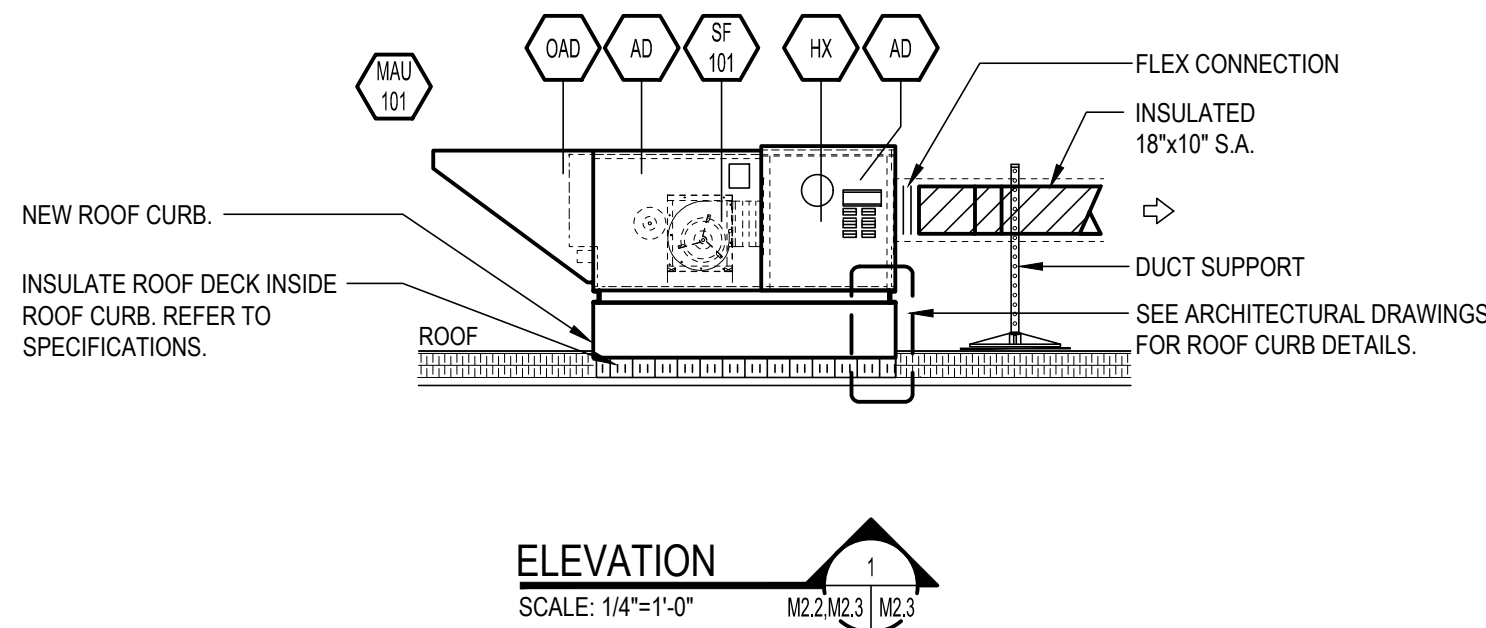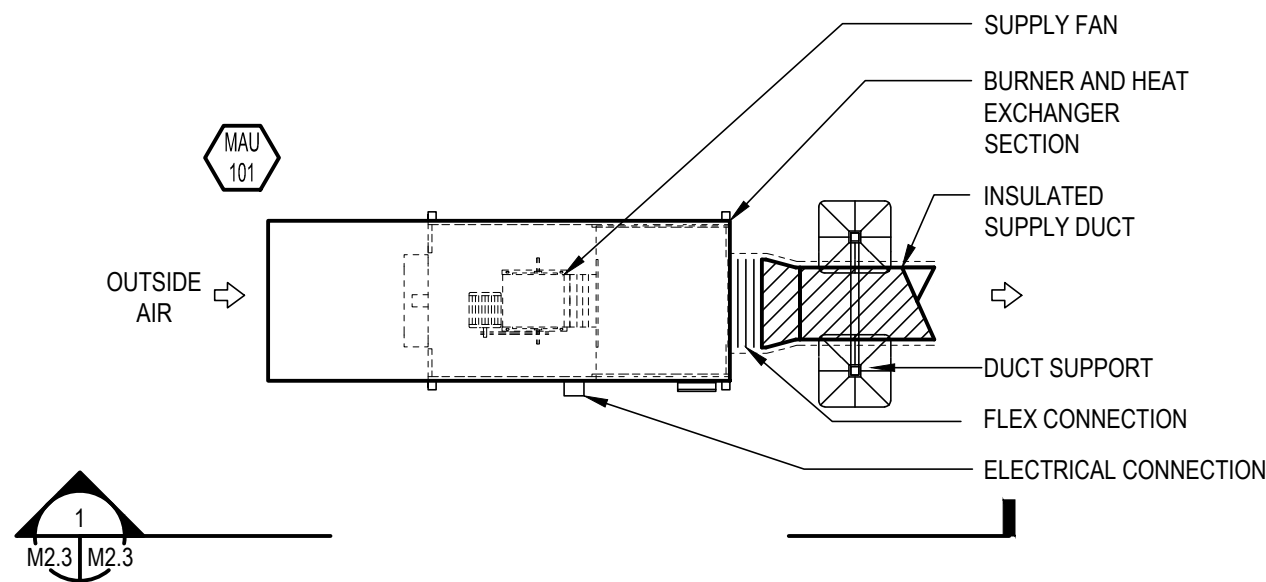

ELEVATION
SCALE: 1/4"=1'-0"



201 QUEENS AVE., UNIT 800
LONDON ON, N6A 1J1


250 CITY CENTRE AVE., SUITE 403
OTTAWA ON, K1R 6K7

Rev No.	DATE	REMARKS
1.	29 JUL 2026	ISSUED FOR COORDINATION
2.	04 AUG 2026	ISSUED FOR BID

ISSUED FOR

DO NOT SCALE THE DRAWINGS. ALL MEASUREMENTS ARE TO BE CHECKED AND VERIFIED ON SITE BY THE CONTRACTOR. ANY DISCREPANCIES ARE TO BE REPORTED TO THE CONSULTANT BEFORE PROCEEDING WITH THE WORK.


COPYRIGHT © ALL RIGHTS RESERVED. ALL DRAWINGS AND RELATED DOCUMENTS ARE THE COPYRIGHT OF THE CONSULTANT AND MUST BE RETURNED UPON REQUEST OR AT THE COMPLETION OF THE WORK. REPRODUCTION OF THESE DRAWINGS OR RELATED DOCUMENTS IN PART OR IN WHOLE, BY ELECTRONIC OR MECHANICAL MEANS, IS FORBIDDEN BY LAW WITHOUT THE PRIOR WRITTEN PERMISSION OF THE CONSULTANT

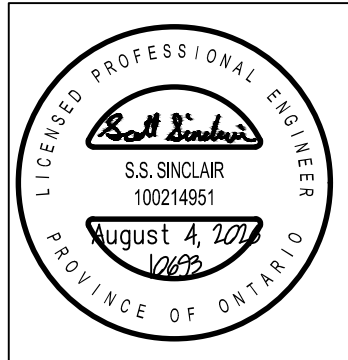

Municipal Child Care Centre
Kitchen Renovation

376 Cambridge Street,
Goderich, ON

MECHANICAL DETAILS

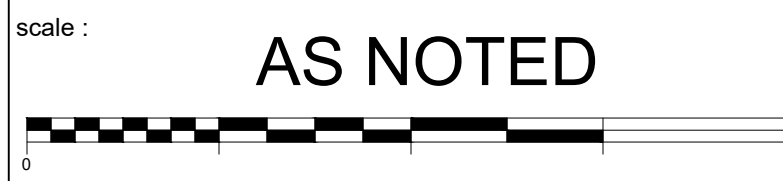

detail :	A - Detail number B - Location drawing C - Location drawing
----------	---

drawn :	BCF
---------	-----

check :	BCF
---------	-----

date :	08/04/26
--------	----------

sheet :	M2.3
---------	------

job :	10693
-------	-------

DRAWING LIST	
E1.1	ELECTRICAL LEGEND, DRAWING LIST, ABBREVIATIONS, GENERAL NOTES, AND SCHEDULES
E1.2	OVERALL FLOOR PLAN - ELECTRICAL
E2.1	PART FLOOR PLANS - ELECTRICAL
E3.1	ELECTRICAL DETAILS

EQUIPMENT SCHEDULE					
DETAILED FROM	BREAKER SIZE	POLES	CONDUCTOR SIZE	CONDUIT SIZE	NOTES
P AIR UNITS					
PANEL 'B'	15	3	3 #12	3/4"	NOTE 4
FANS					
PANEL 'B'	15	3	3 #12	3/4"	

E SCHEDULE			
OLTS	SYSTEM WATTS	EQUAL MANUFACTURERS	NOTES
120	24	CFI SERIES SBP, COLUMBIA SERIES NBT	
120	25	CFI SERIES SBP, COLUMBIA SERIES NBT	

ELECTRICAL LEGEND		
SYMBOL	DESCRIPTION	MOUNTING
<u>LIGHTING</u>		
	LUMINAIRE	RECESSED - SEE LUMINAIRE SCHEDULE
	LUMINAIRE	SURFACE - SEE LUMINAIRE SCHEDULE
	EMERGENCY BATTERY PACK c/w DUAL HEADS	WALL MOUNTED
	EMERGENCY LIGHT REMOTE HEAD	SURFACE MOUNTED
	EMERGENCY LIGHT REMOTE DUAL HEADS	CEILING MOUNTED
	SINGLE POLE SWITCH	REFER TO MOUNTING HEIGHT DETAIL
	ROOM CONTROL	CEILING ABOVE SWITCHES
	OCCUPANCY SENSORS	CEILING MOUNTED
<u>POWER</u>		
	15/20 AMP 125 VOLT 3 WIRE GROUNDED DUPLEX RECEPTACLE CSA 5-20R	REFER TO MOUNTING HEIGHT DETAIL
	15/20 AMP 125 VOLT 3 WIRE GROUNDED DUPLEX RECEPTACLE CSA 5-20R	SEE MOUNTING HEIGHT DETAIL
	TWO 15/20 AMP 120 VOLT 3 WIRE GROUNDED DUPLEX RECEPTACLES UNDER COMMON PLATE	SEE MOUNTING HEIGHT DETAILS
	50 AMP 250 VOLT 4 WIRE GROUNDED RANGE RECEPTACLE	SEE MOUNTING HEIGHT DETAILS
	DIRECT POWER CONNECTION	AS NOTED
	MOTOR	
	MOTOR c/w DISCONNECT SWITCH	
	FUSED DISCONNECT SWITCH	
	MAGNETIC STARTER	
	CONTACTOR	
	ELECTRICAL PANEL	SURFACE
<u>FIRE ALARM</u>		
	135° RATE-OF-RISE/FIXED TEMPERATURE FIRE DETECTOR	CEILING MOUNTED
	FIRE ALARM ANNUNCIATOR	WALL 1800mm (70") A.F.F. TO TOP OF UNIT
	FIRE ALARM CONTROL PANEL	REFER TO FIRE ALARM MOUNTING HEIGHT DETAIL


ABBREVIATIONS			
C	CONDUIT	RR	REMOVE AND REINSTALL
CL	CEILING MOUNTED	REL	IF DASHED - EXISTING TO BE RELOCATED
DS	UN-FUSED DISCONNECT SWITCH	REL	IF SOLID - EXISTING IN NEW LOCATION
EX	EXISTING TO REMAIN	REM	EXISTING TO BE REMOVED
FHP	FRACTIONAL HORSEPOWER	REP	EXISTING TO BE REPLACED WITH NEW
FVNR	FULL VOLTAGE NON-REVERSING STARTER C/W HOA SWITCH	SM	SURFACE MOUNTED
FLA	FULL LOADS AMPS	SPD	SURGE PROTECTION DEVICE
GFCI	GROUND FAULT CIRCUIT INTERRUPTER	WP	WEATHERPROOF
P	POLE	WG	WIRE GUARD
PH	PHASE	OC	OVER COUNTER

[illegible]

The seal is circular with the text "LICENSED PROFESSIONAL ENGINEER" around the top and "PROVINCE OF ONTARIO" around the bottom. In the center, it reads "I.J.L. MILLER", "100863905", and "A/C DA 2016" with a handwritten signature below.

ELECTRICAL LEGEND, DRAWING LIST, ABBREVIATIONS, ETC.

scale : AS NOTED	
	
detail :	A - Detail number B - Location drawing C - Location drawing
	
drawn :	RK
date :	08/04/26
job :	10693
sheet : E1.1	

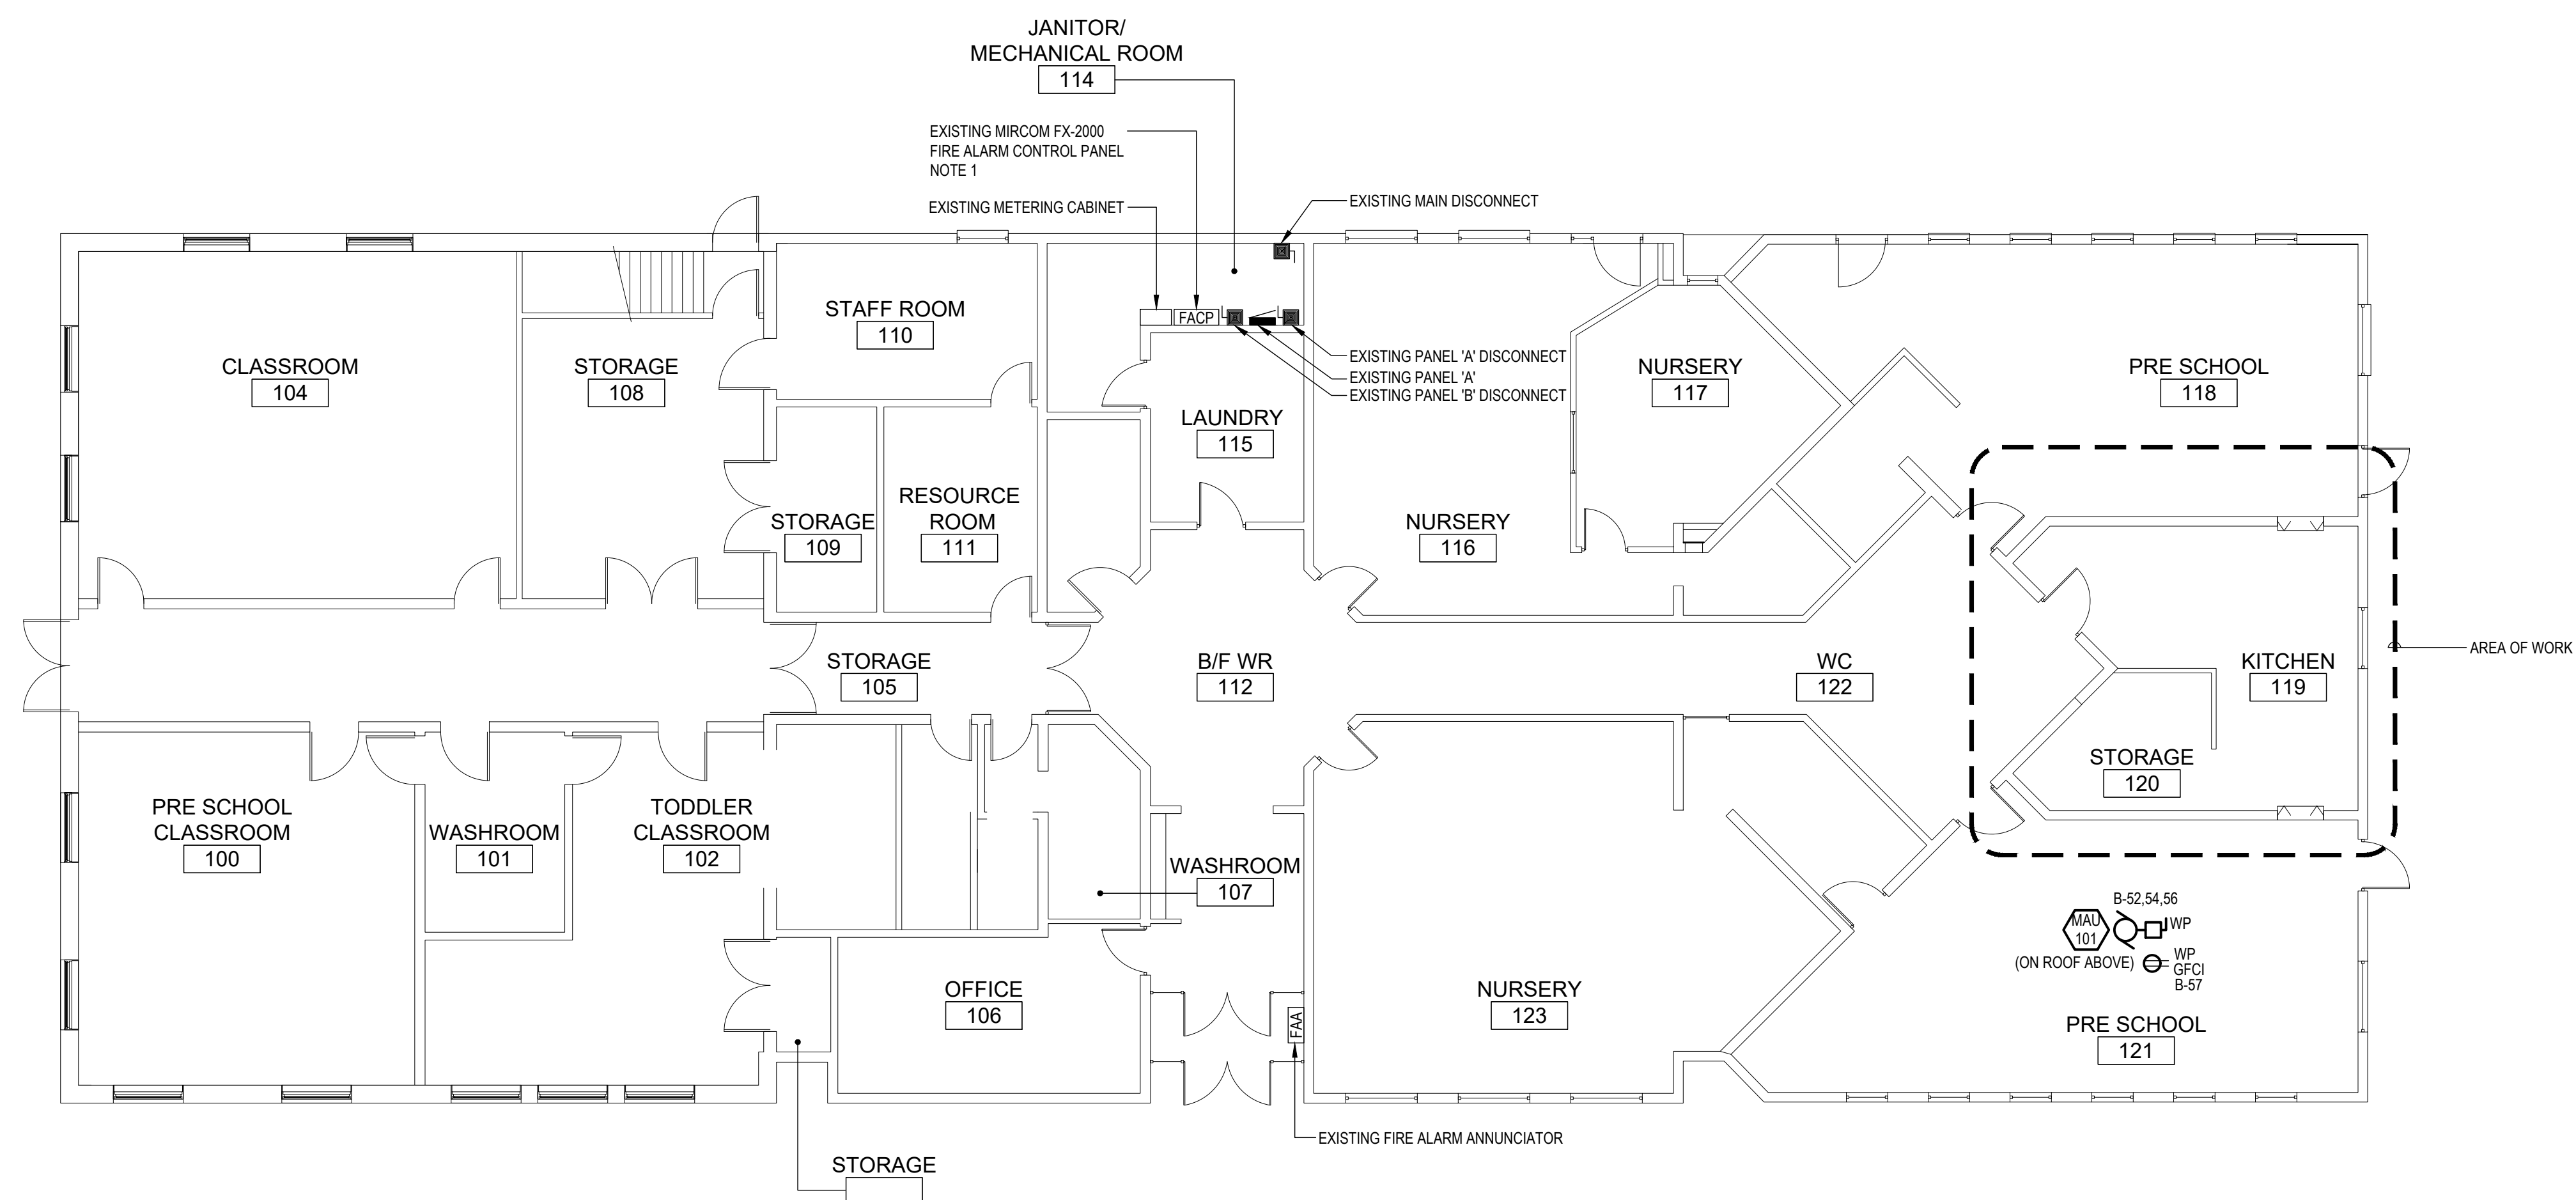

SCALE: 1/8"=1'-0"


NOTES:

1. PROVIDE RM-1008A RELAY MODULE IN EXISTING PANEL FOR MONITORING AND CONTROL OF NEW KITCHEN HOOD FIRE SUPPRESSION EQUIPMENT. ACTIVATION OF FIRE SUPPRESSION SYSTEM TO ACTIVATE FIRE ALARM. REFER TO KITCHEN HOOD STARTER SCHEMATIC. CONSULT WITH FIRE ALARM MANUFACTURER FOR ALL REQUIRED ACCESSORIES.

[illegible]

DO NOT SCALE THE DRAWINGS. ALL MEASUREMENTS ARE TO BE CHECKED AND VERIFIED ON SITE BY THE CONTRACTOR. ANY DISCREPANCIES ARE TO BE REPORTED TO THE CONSULTANT BEFORE PROCEEDING WITH THE WORK.

COPYRIGHT © ALL RIGHTS RESERVED. ALL DRAWINGS AND RELATED DOCUMENTS ARE THE COPYRIGHT OF THE CONSULTANT AND MUST BE RETURNED UPON REQUEST OR AT THE COMPLETION OF THE WORK. REPRODUCTION OF THESE DRAWINGS OR RELATED DOCUMENTS IN PART OR IN WHOLE, BY ELECTRONIC OR MECHANICAL MEANS, IS FORBIDDEN BY LAW WITHOUT THE PRIOR WRITTEN PERMISSION OF THE CONSULTANT.

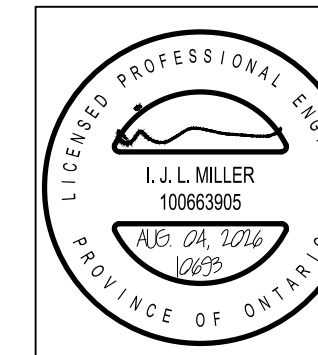

376 Cambridge Street,
Goderich, ON

OVERALL FLOOR PLAN ELECTRICAL


check : IJM

sheet :

10693

sheet :


E1.2

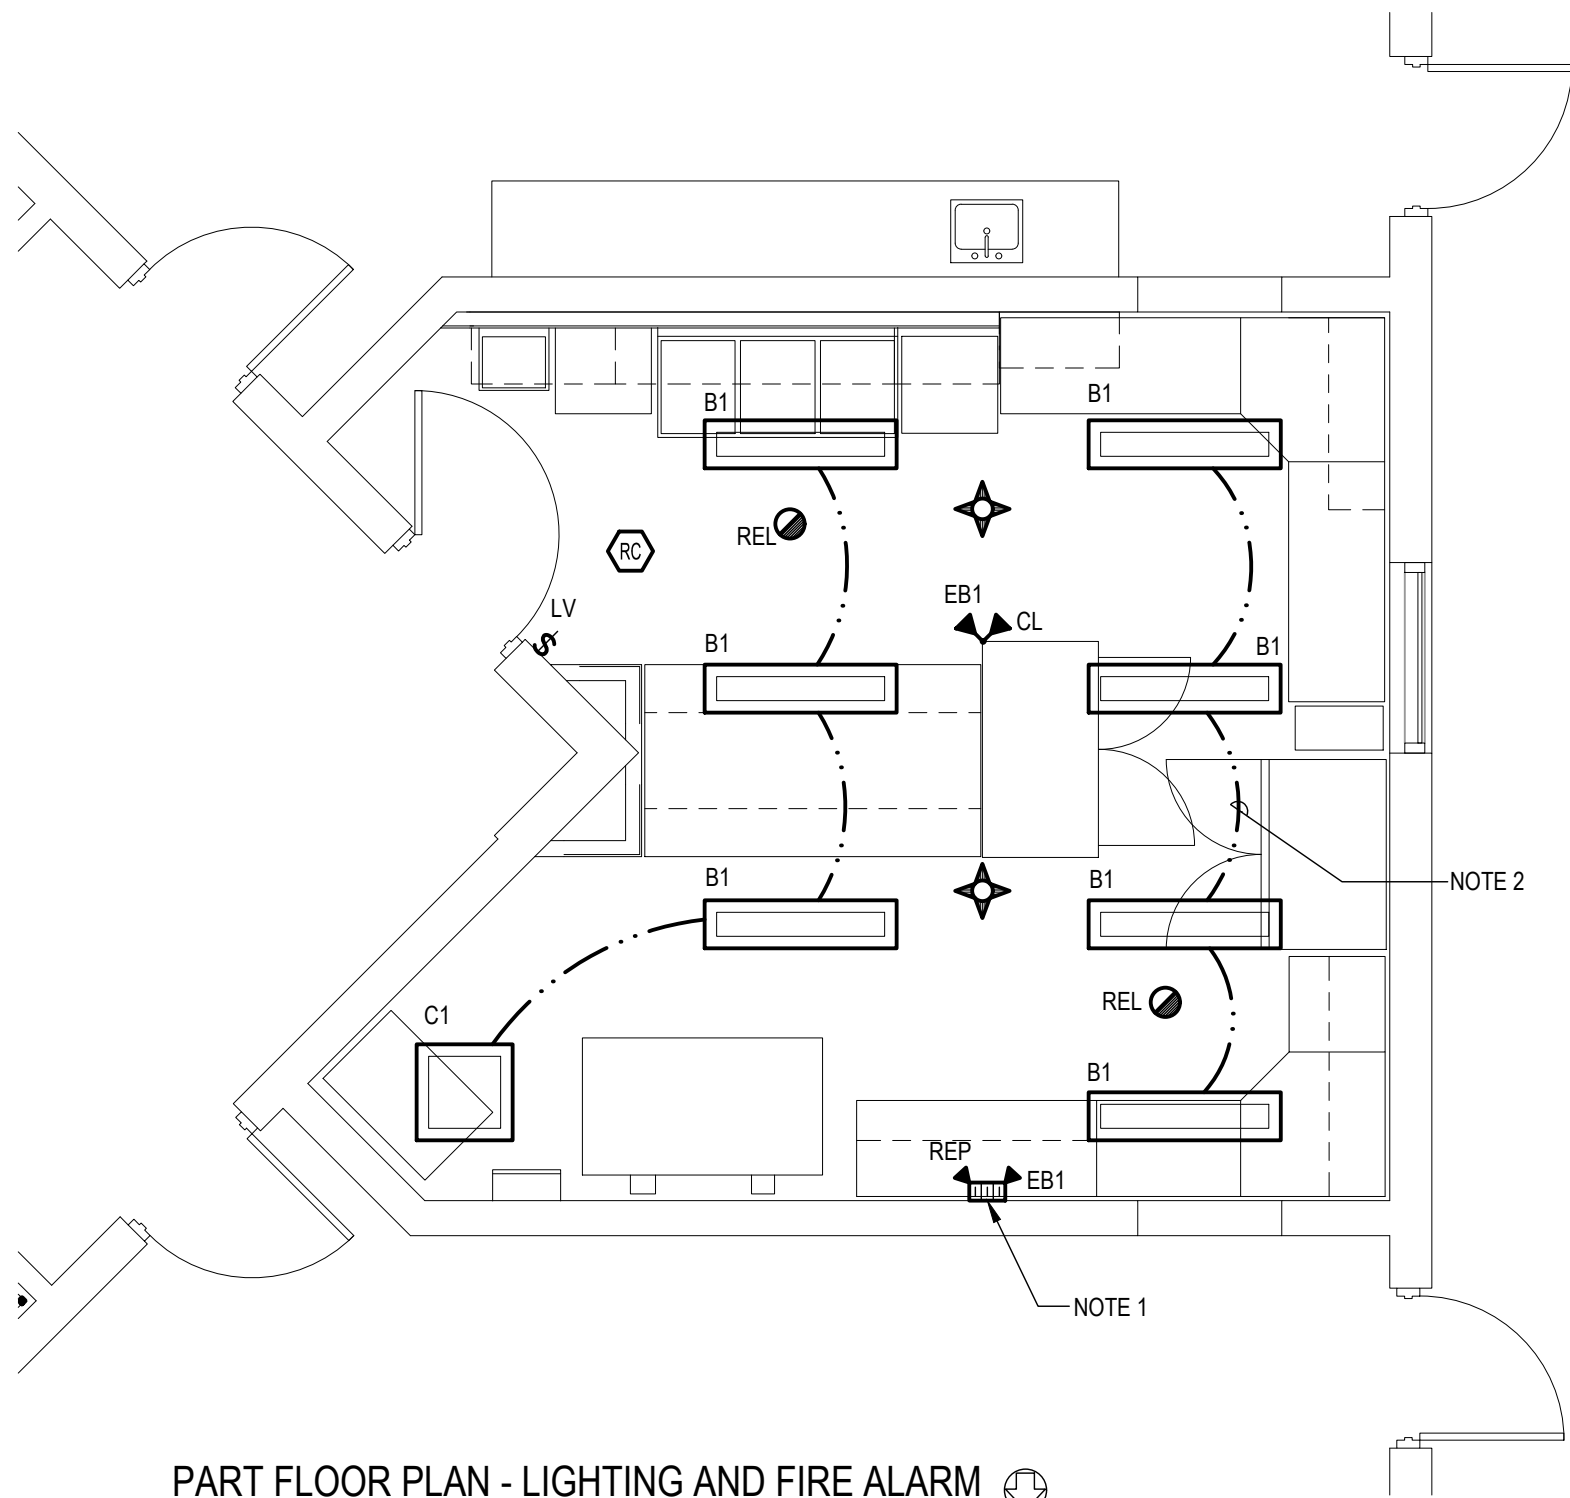

PART FLOOR PLAN - LIGHTING AND FIRE ALARM
SCALE: 1/4"=1'-0"

NOTES:


1. REWORK/ EXTEND EXISTING EMERGENCY LIGHT CIRCUITS SERVING LIGHTS IN OTHER AREAS TO NEW BATTERY PACK. CONFIRM VOLTAGE OF EXISTING PRIOR TO ORDERING NEW.
2. REWORK/ EXTEND EXISTING UNSWITCHED LIGHTING CIRCUIT SERVING ROOM TO NEW LUMINAIRES.

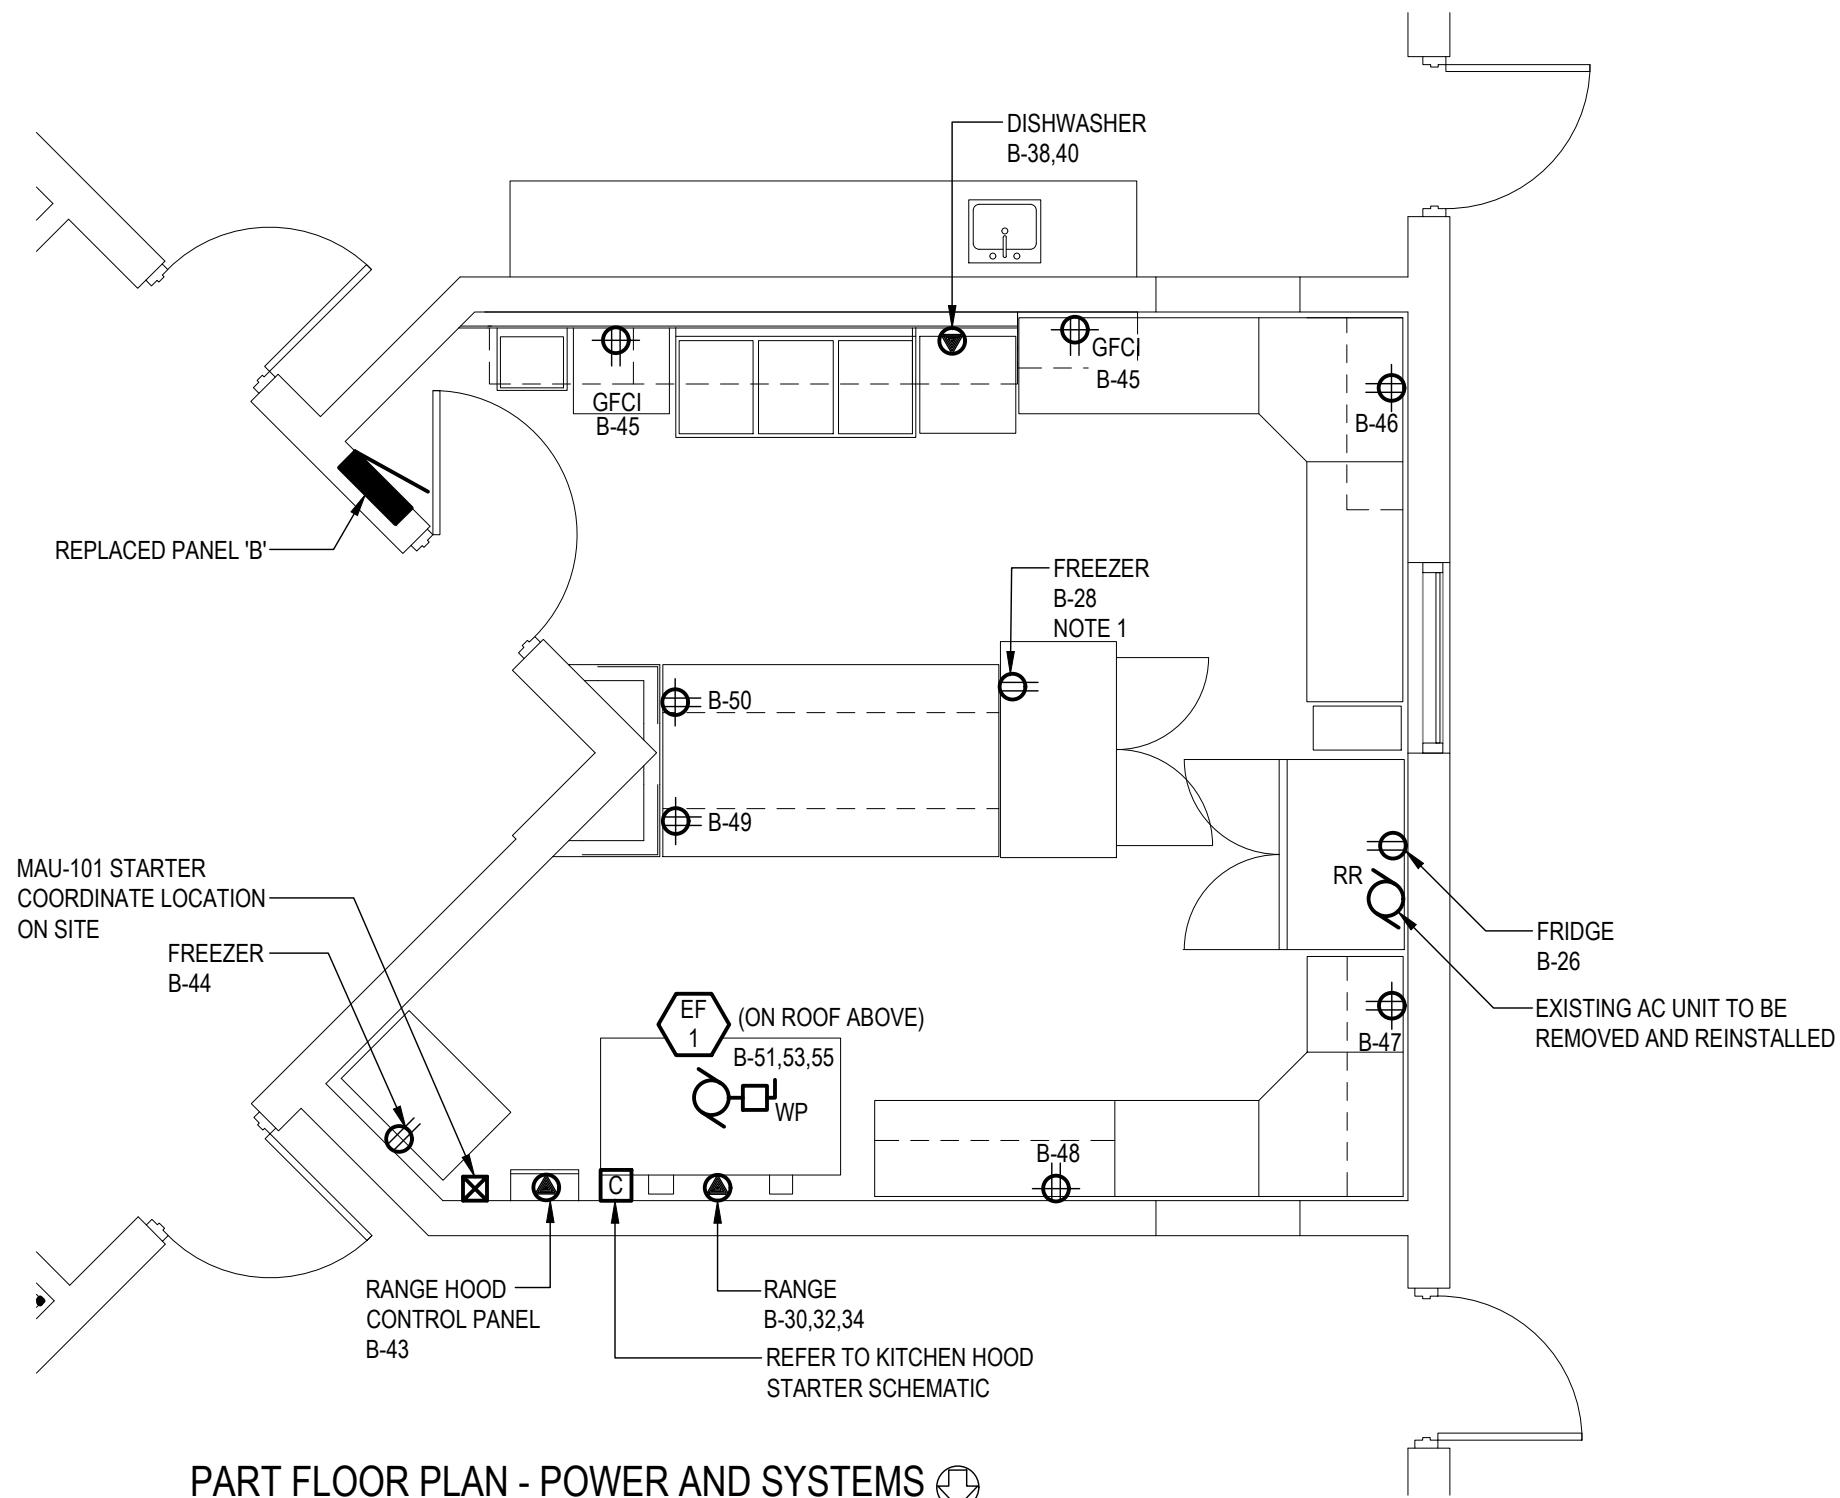

PART FLOOR PLAN - POWER AND SYSTEMS
SCALE: 1/4"=1'-0"

NOTES:


1. RECEPTACLE MOUNTED ON WORK TABLE. RUN CONDUIT ALONG UNDERSIDE OF LOWER TABLE SHELF TO NEW WALL. COORDINATE WITH KITCHEN EQUIPMENT SUPPLIER.

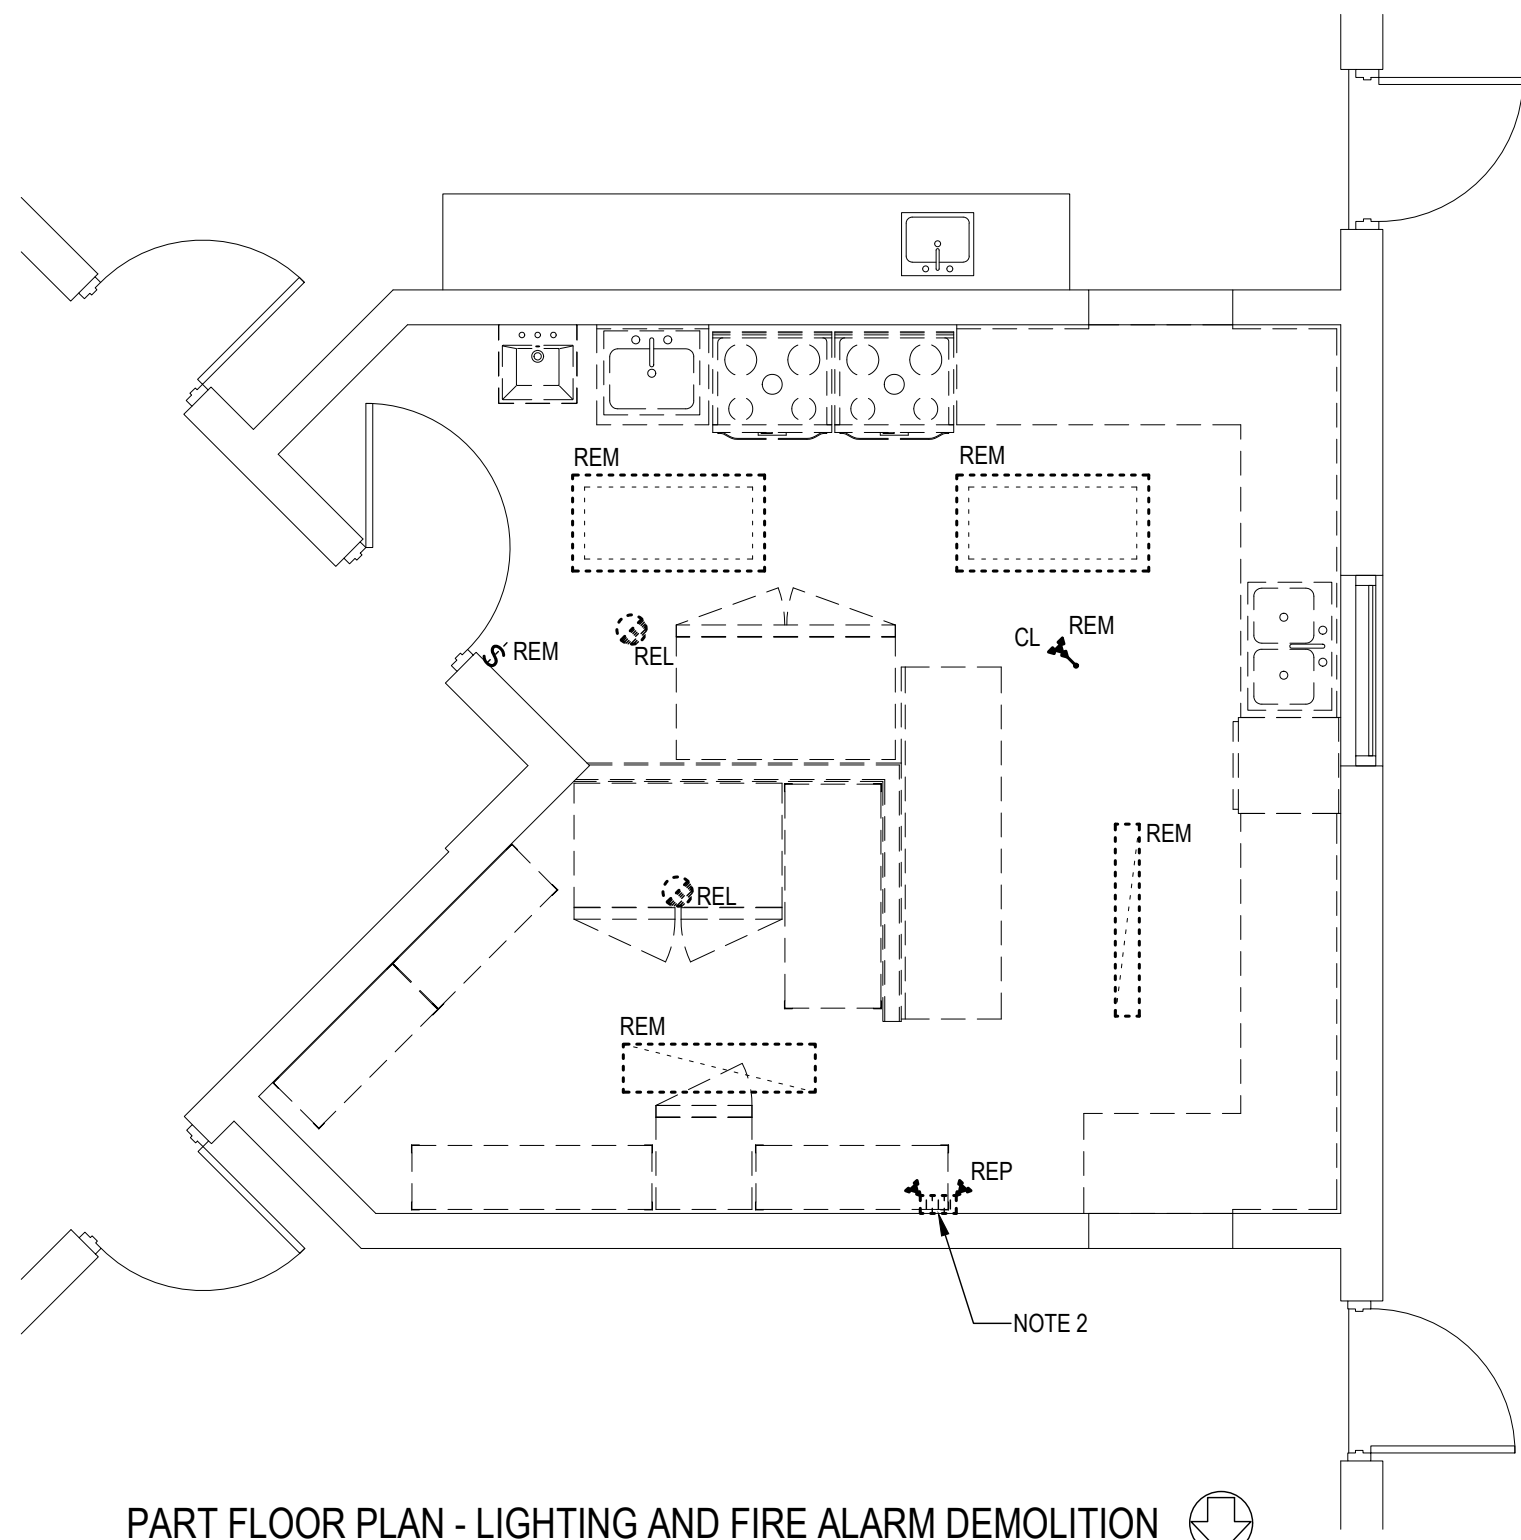

PART FLOOR PLAN - LIGHTING AND FIRE ALARM DEMOLITION
SCALE: 1/4"=1'-0"

NOTES:

1. DEVICES SHOWN FOR REFERENCE ONLY. UNLESS NOTED OTHERWISE, COMPLETELY REMOVE ALL LIGHTING AND FIRE ALARM DEVICES WITHIN KITCHEN. REMOVE ALL REDUNDANT CABLING AND CONDUIT BACK TO SOURCE.
2. EXISTING EMERGENCY LIGHT CIRCUITS SERVING LIGHTS IN OTHER AREAS TO BE REWORKED TO NEW BATTERY PACK.

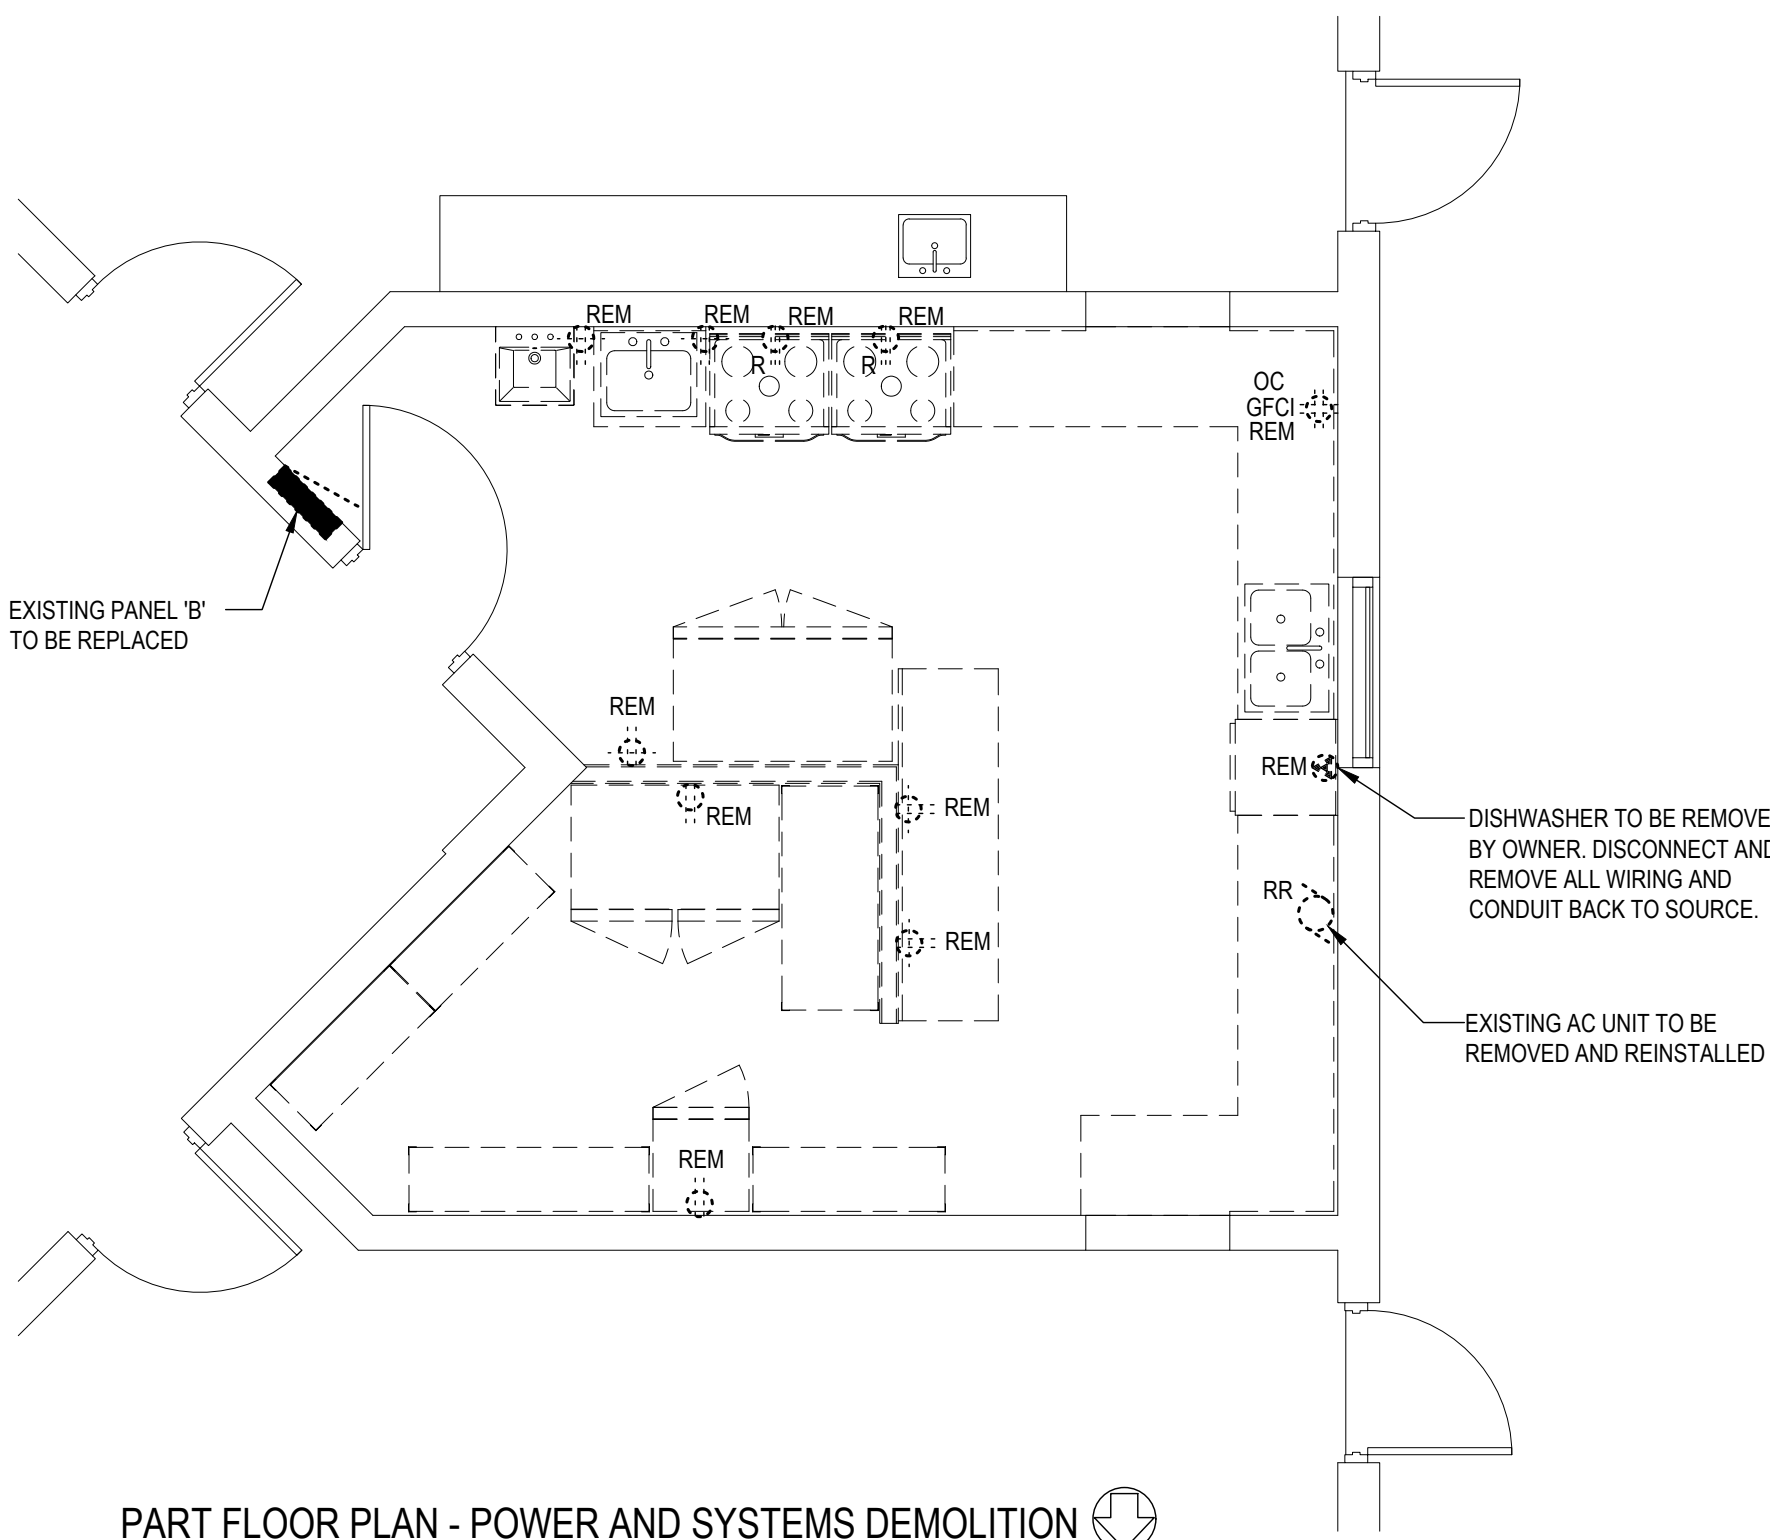

PART FLOOR PLAN - POWER AND SYSTEMS DEMOLITION
SCALE: 1/4"=1'-0"

NOTES:

1. DEVICES SHOWN FOR REFERENCE ONLY. UNLESS NOTED OTHERWISE, COMPLETELY REMOVE ALL POWER AND SYSTEM DEVICES WITHIN KITCHEN. REMOVE ALL REDUNDANT CABLING AND CONDUIT BACK TO SOURCE.



201 QUEENS AVE., UNIT 800
LONDON ON, N6A 1J1


250 CITY CENTRE AVE., SUITE 403
OTTAWA ON, K1R 6K7

Rev No.	DATE	REMARKS
2.	04 AUG 2026	ISSUED FOR BID
1.	29 JUL 2026	ISSUED FOR COORDINATION

ISSUED FOR

DO NOT SCALE THE DRAWINGS. ALL MEASUREMENTS ARE TO BE CHECKED AND VERIFIED ON SITE BY THE CONTRACTOR. ANY DISCREPANCIES ARE TO BE REPORTED TO THE CONSULTANT BEFORE PROCEEDING WITH THE WORK.


COPYRIGHT © ALL RIGHTS RESERVED. ALL DRAWINGS AND RELATED DOCUMENTS ARE THE COPYRIGHT OF THE CONSULTANT AND MUST BE RETURNED UPON REQUEST OR AT THE COMPLETION OF THE WORK. REPRODUCTION OF THESE DRAWINGS OR RELATED DOCUMENTS IN PART OR IN WHOLE, BY ELECTRONIC OR MECHANICAL MEANS, IS FORBIDDEN BY LAW WITHOUT THE PRIOR WRITTEN PERMISSION OF THE CONSULTANT

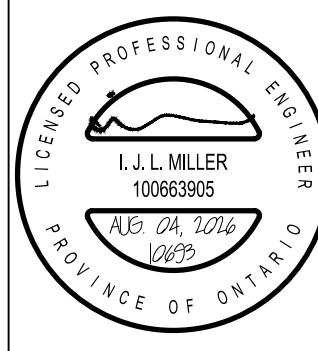

Municipal Child Care Centre
Kitchen Renovation

376 Cambridge Street,
Goderich, ON

PART FLOOR PLANS
ELECTRICAL





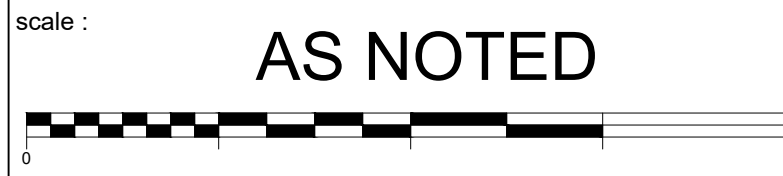



detail :	A - Detail number B - Location drawing C - Location drawing	A B C
----------	---	-------------

drawn :	RK	check :	IJM
---------	----	---------	-----

date :	08/04/26	sheet :	E2.1
--------	----------	---------	------

job :	10693
-------	-------

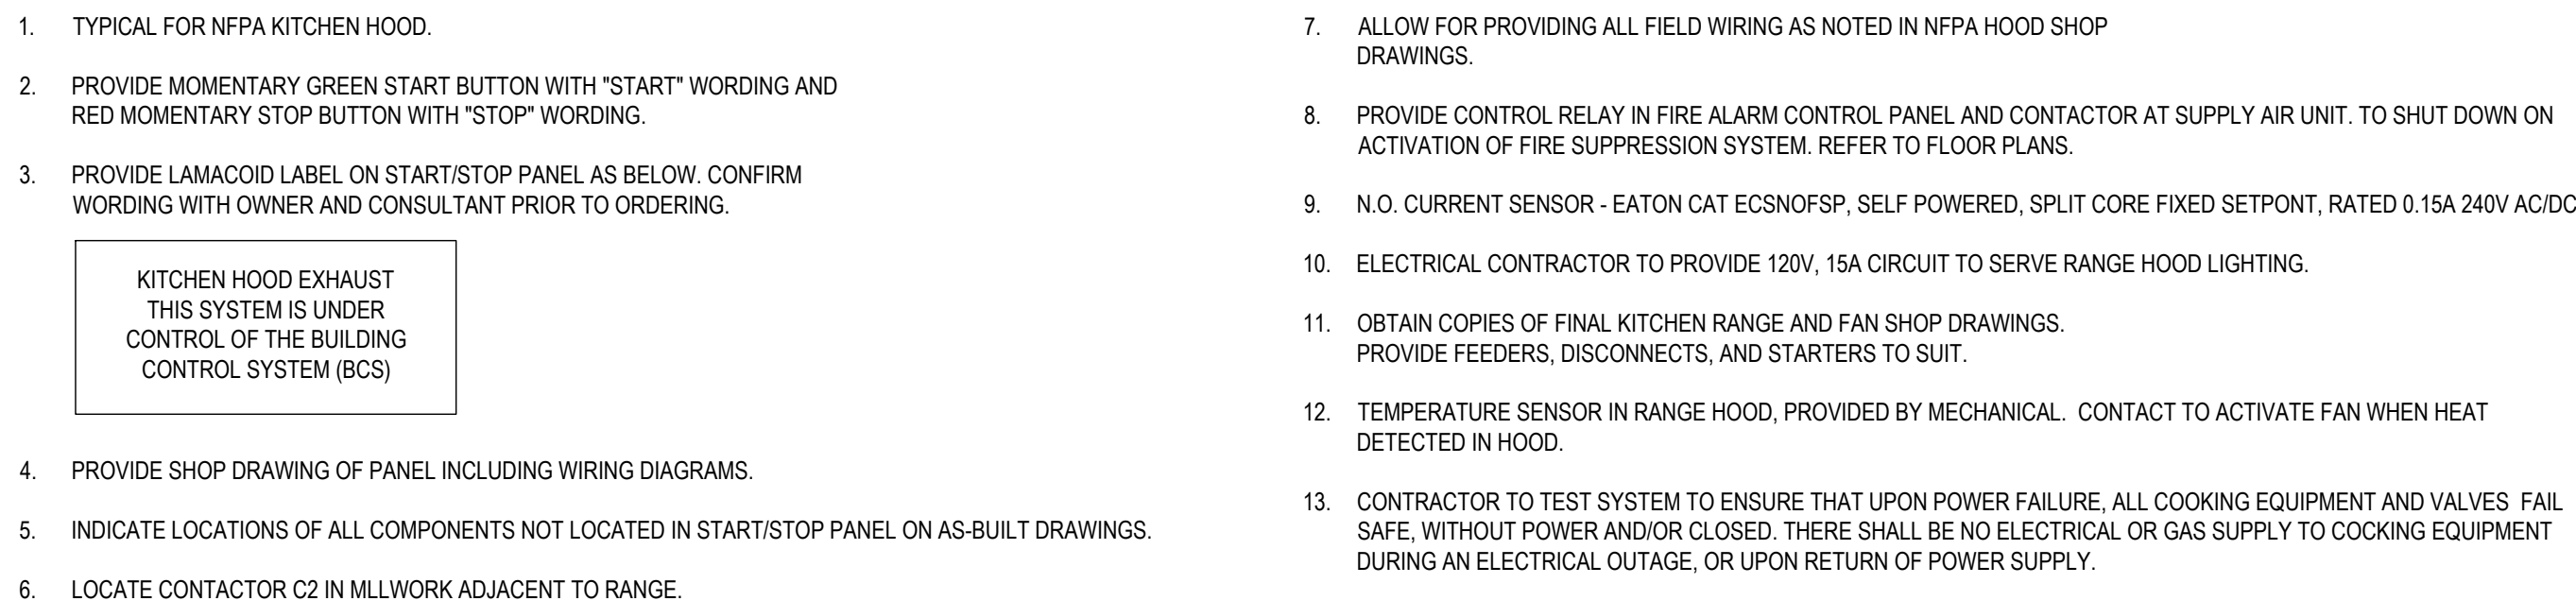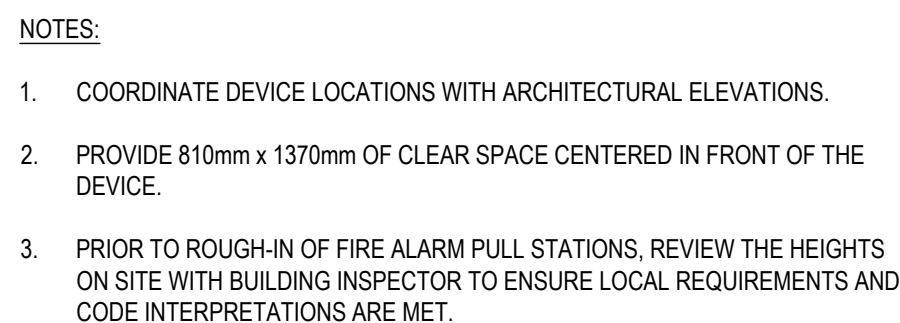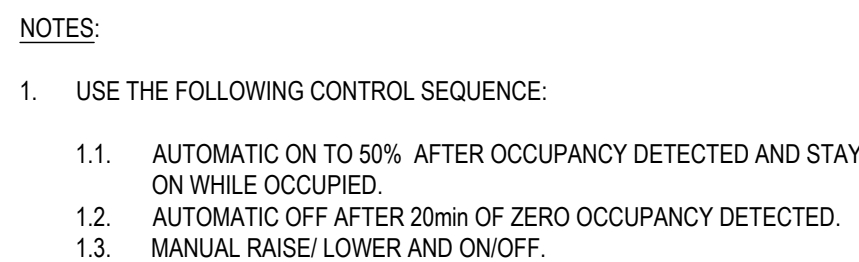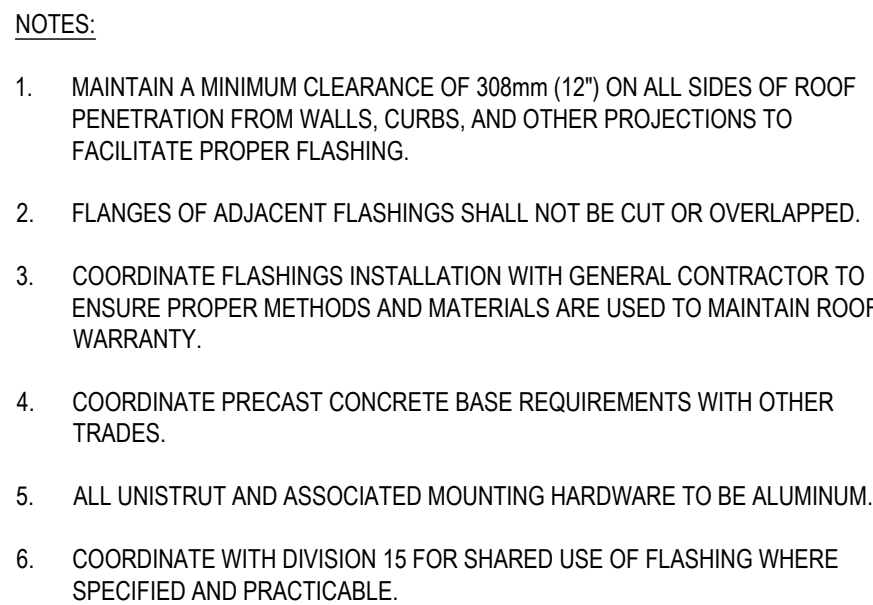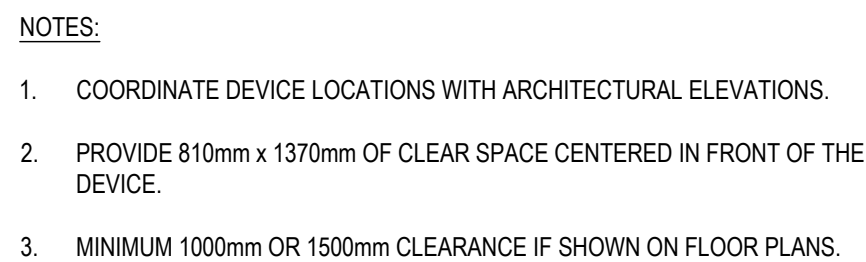

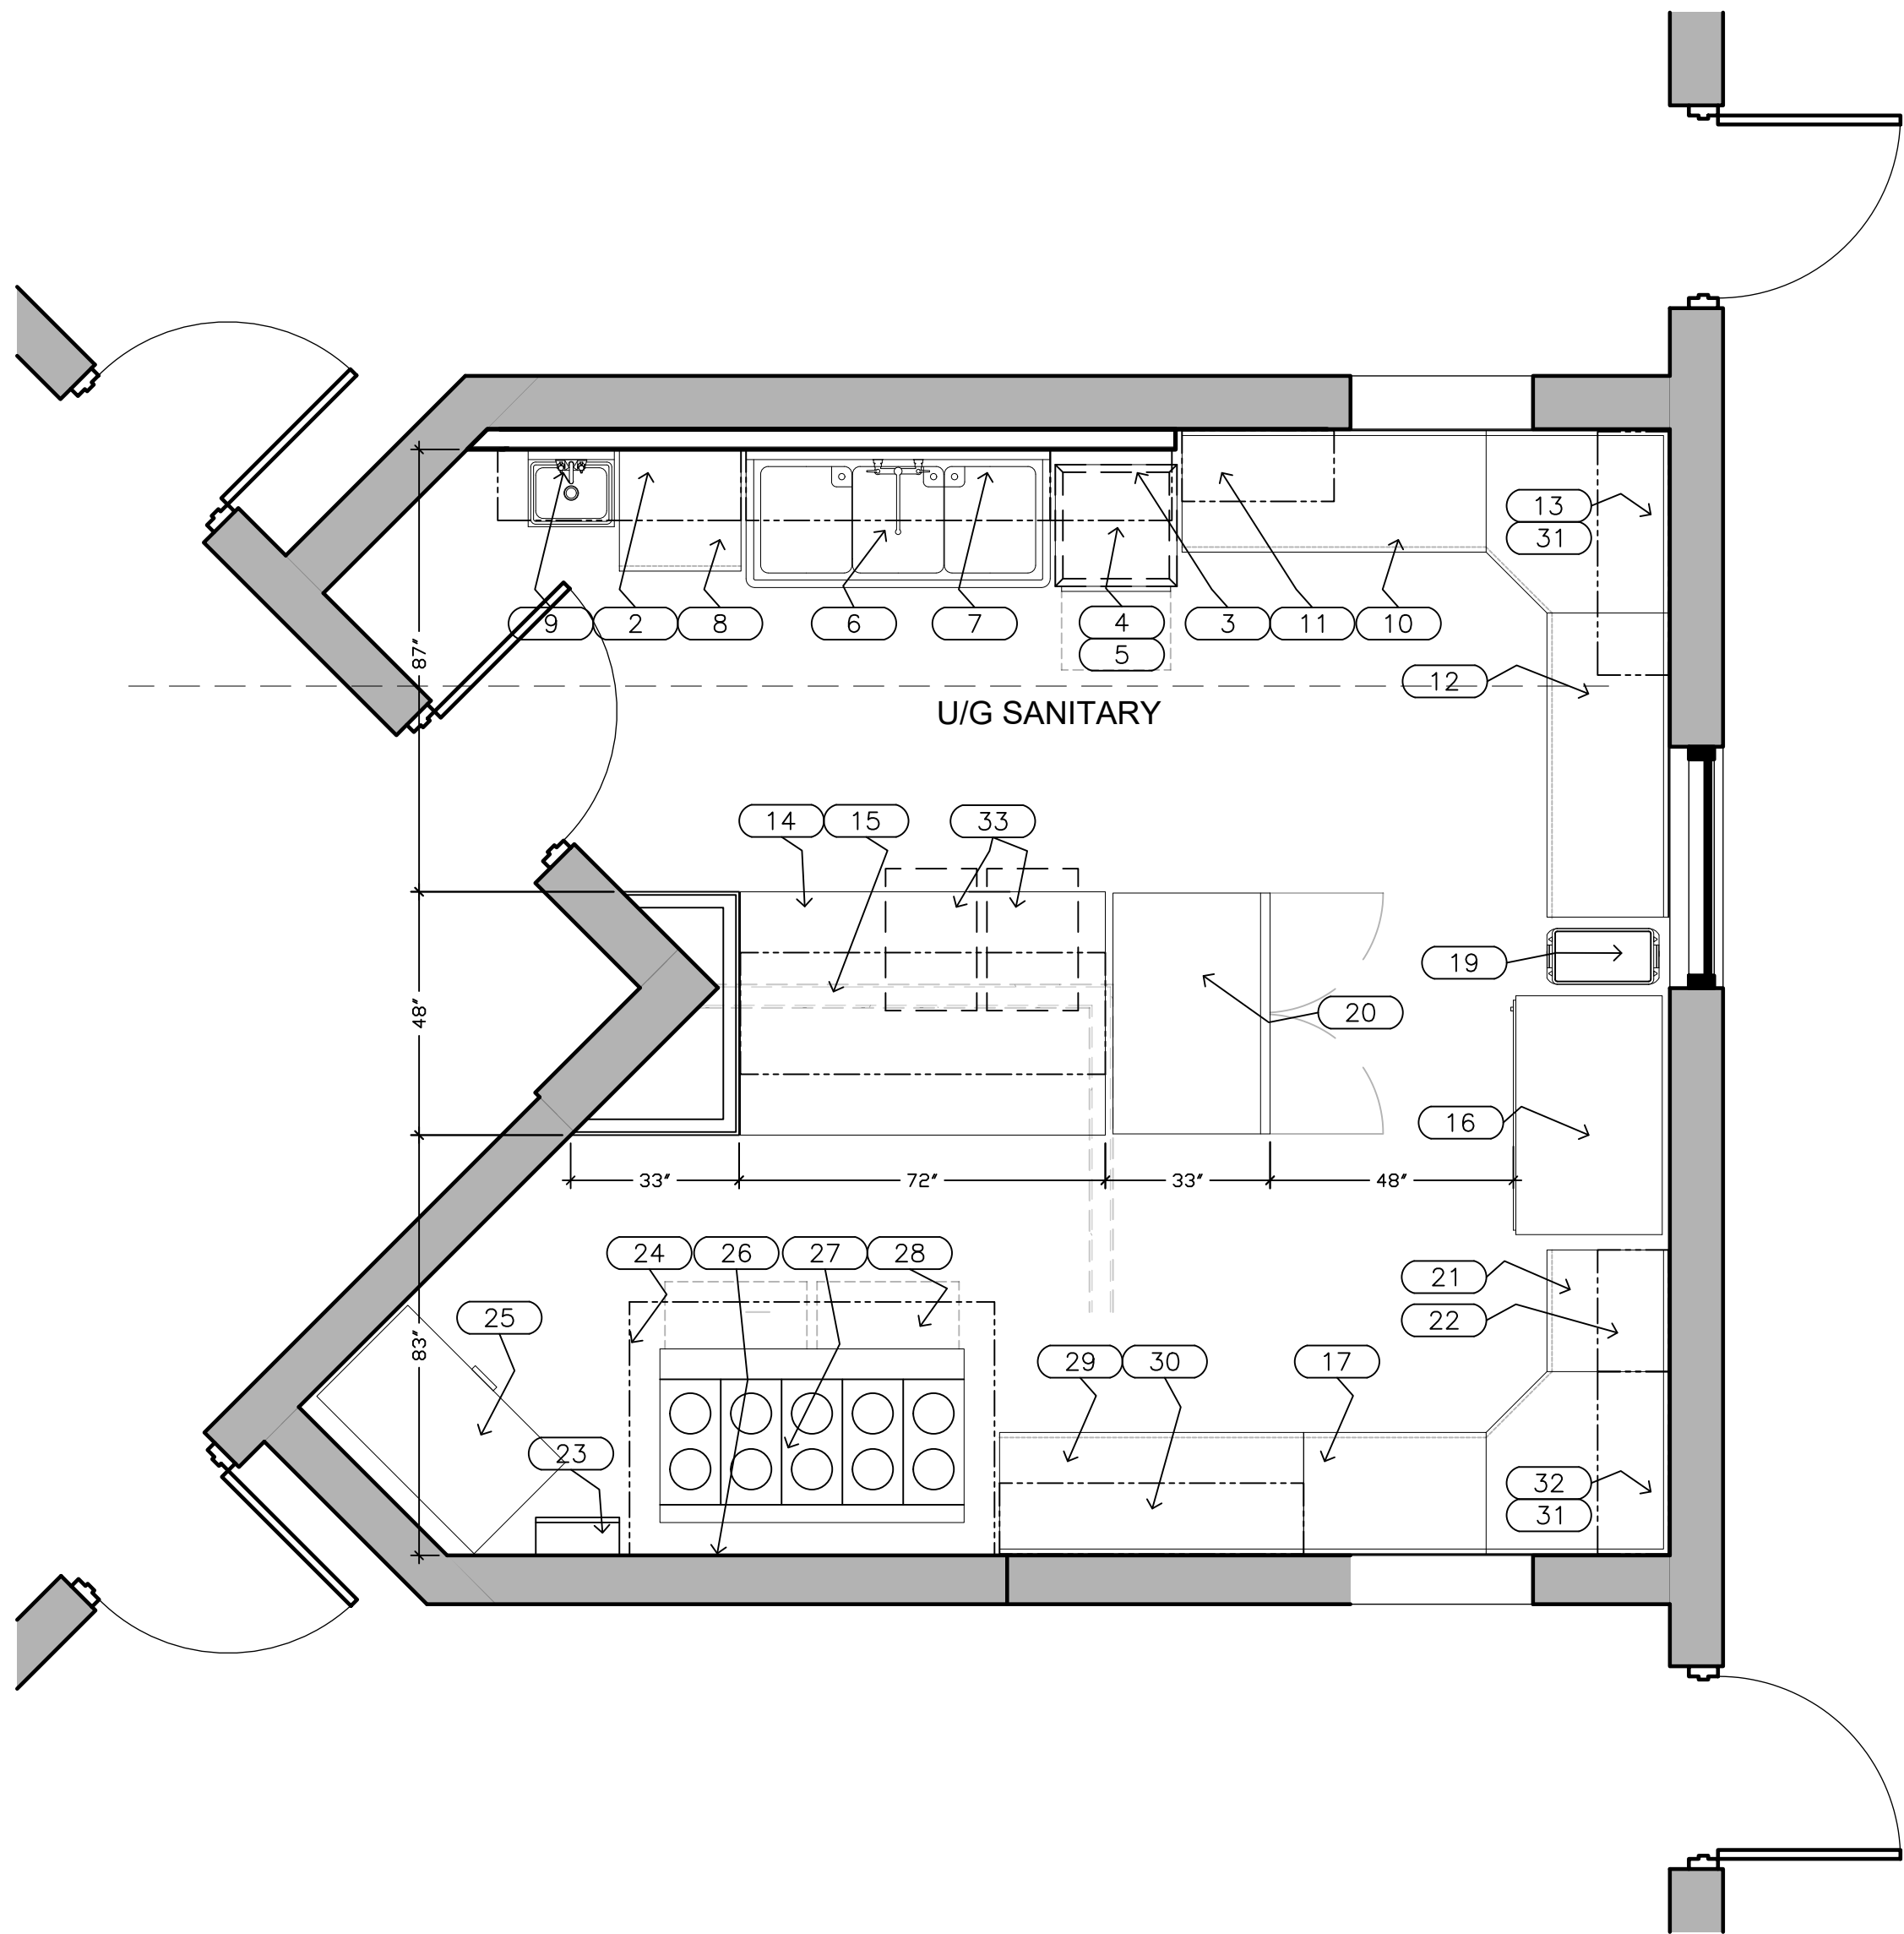

EQUIPMENT SCHEDULE				
ITE M NO	QTY	EQUIPMENT CATEGORY	MANUFACTURER	MODEL NUMBER
1	1	GREASE TRAP - BY OTHERS (NOT SHOWN)		
2	1	STAINLESS WALL CABINET	TARRISON	TC-C1448W
3	1	STAINLESS WALL CABINET	TARRISON	TC-C1424W
4	1	WAREWASHER, UNDERCOUNTER, HIGH TEMP	MOYER DIEBEL	501HT
5	1	STAND, RACK	MOYER DIEBEL	17-RS (0708757)
6	1	STAINLESS THREE COMPARTMENT SINK	TARRISON	TA-CD5318-KIT
7	1	STAINLESS WALL CABINET	TARRISON	TC-C1460W
8	1	STAINLESS BASE CABINET	TARRISON	TC-C2424BD
9	1	STAINLESS HAND SINK	TARRISON	TA-HSF-14
10	1	STAINLESS BASE CABINET	TARRISON	TC-C2460BD
11	1	STAINLESS WALL CABINET	TARRISON	TC-C1430W
12	1	STAINLESS CABINET BASE, SLIDING DOORS	TARRISON	TC-C2460BD
13	1	STAINLESS WALL CABINET	TARRISON	TC-C1448W
14	1	STAINLESS WORK TABLE (*CUSTOM)	TARRISON	TF-SWT4872-LB3S
15	1	STAINLESS DOUBLE OVERSHELF, TABLE MOUNT	TARRISON	TF-DOS2472
16	1	DISPLAY CASE, REFRIGERATED	TRUE MFG.	GDM-41-HC-LD
17	1	STAINLESS BASE CABINET	TARRISON	TC-C2436CB
18	1	SPARE NUMBER		
19	1	WASTE CONTAINER	RUBBERMAID	FG354060GRAY
20	1	RH DEPENDABLE FREEZER	HABCO	SF46HCSA
21	2	STAINLESS BASE CABINET	TARRISON	TC-C2424BD
22	1	STAINLESS WALL CABINET	TARRISON	TC-C1424W
23	1	FIRE SUPPRESSION - BY OTHERS		
24	1	EXHAUST HOOD - BY OTHERS		
25	1	CHEST FREEZER	DANBY	DCF100A5WDB
26	1	S.S. INSULATED WALL PANELS - BY OTHERS		
27	1	SS684 SENTRY ELECTRIC RANGE	GARLAND	SS684
28	1	S.S. ENCLOSURE PANELS IF REQ. - BY OTHERS		
29	1	STAINLESS BASE CABINET	TARRISON	TC-C2460BD
30	1	STAINLESS WALL CABINET	TARRISON	TC-C1460W
31	1	STAINLESS CORNER BASE CABINET	TARRISON	TC-C2436CB
32	1	STAINLESS WALL CABINET	TARRISON	TC-1436W
33	2	BUSSING CARTS	METRO	BC-2030-3DBL



- GENERAL NOTES:
1. THE FOOD SERVICE EQUIPMENT TO BE ASSEMBLED AND SET INTO PLACE INCLUDES GOODS SUPPLIED UNDER FOOD SERVICES CONTRACT ONLY UNLESS OTHERWISE NOTED.
 2. THE CRATING MATERIALS WILL BE REMOVED FROM THE EQUIPMENT AND THE PREMISES BY THE INSTALLATION CREW AND PLACED WHERE DIRECTED BY THE OWNER OR GENERAL CONTRACTOR. REMOVAL FROM THE SITE IS THE RESPONSIBILITY OF THE GENERAL CONTRACTOR OR OWNER, UNLESS OTHERWISE NOTED.
 3. NO COMBUSTIBLE MATERIALS SHALL BE USED WITHIN 18" OF THE EXHAUST HOOD(S) OR EXHAUST DUCT(S).
 4. ANY ROOF OR WALL PENETRATIONS, FLOOR RECESSES OR OTHER "STRUCTURAL" ITEMS ARE THE RESPONSIBILITY OF THE GENERAL CONTRACTOR. FLOORS SHOULD BE PROPERLY SEALED PRIOR TO EQUIPMENT INSTALLATION.
 5. THE MILLWORK CONTRACTOR SHOULD WORK TO DIMENSIONS PROVIDED ON SHOP DRAWINGS FOR STAINLESS STEEL TOPS.
 6. THE GENERAL CONTRACTOR TO PROVIDE BACKING IN WALLS WHERE PROVIDED TO SUPPORT SHELVES, CABINETS OR OTHER WALL HUNG FIXTURES. CONTACT PROJECT MANAGER FOR VERIFICATION OF BACKING REQUIREMENTS BEFORE BOARDING.
 7. THE EQUIPMENT CONTRACTOR WILL PROVIDE PROPER VOLETS, SLEEVES, MOUNTING BRACKETS, ETC. TO ACCOMMODATE SERVICE SUPPLY WITHIN THE FIXTURES.
 8. THE SUPPLIER OF THE EXHAUST FANS AND/OR MAKE-UP AIR UNITS TO PROVIDE ROOF CURB(S) FOR INSTALLATION BY THE GENERAL CONTRACTOR. GENERAL CONTRACTOR RESPONSIBLE FOR SUPPLY AND INSTALLATION OF ROOF SLEEPERS AND/OR STRUCTURAL SUPPORT OF ROOFTOP EQUIPMENT. DUCT SHAFT SHALL BE PROVIDED BY THE GENERAL CONTRACTOR IN ACCORDANCE WITH NFPA REGULATIONS, UNLESS OTHERWISE NOTED.
 9. THE GENERAL CONTRACTOR SHALL SUPPLY JOB SITE LIGHT, HEAT AND ELECTRIC POWER AT NO CHARGE DURING INSTALLATION PERIOD.
 10. THIS DRAWING IS THE PROPERTY OF RUSSELL HENDRIX AND IS LOANED SUBJECT TO THE CONDITION THAT IT IS NOT TO BE COPIED, REPRODUCED, OR DISTRIBUTED EITHER IN WHOLE OR PART. IT IS NOT TO BE USED DIRECTLY OR INDIRECTLY EXCEPT WITH THE WRITTEN AUTHORITY OF RUSSELL HENDRIX.

NOTES/APPROVALS:

03	06.19.26	GENERAL REVISION
02	04.22.26	#21,22,#25
01	04.16.26	ISSUED FOR REVIEW
REV#	DATE	DESCRIPTION
CLIENT/PROJECT		

GODERICH
CHILD
CARE

SCALE:	3/8"=1'-0"	DATE:	04.16.26
DRAWN BY:	B.C.	APPROVED:	
DRAWING TITLE:			
EQUIPMENT PLAN			

DRAWING NO:

K1.01

PROJECT ID:

REVISION NO:
03